


RENOVATION OF EAST GATE & DEVELOPMENT OF SECURITY ROOM AT MTPF AVNL AMBERNATH, MAHARASHTRA		
LIST OF DRAWINGS		
S. No.	DESCRIPTION	DRAWING NO.
	EAST GATE	
A	ARCHITECTURAL DRAWING	
1	EAST GATE -SITE PLAN	ARC/MH/AMBRT/01
2	EAST GATE-ROAD SECTIONS	ARC/MH/AMBRT/01A
B	CATCHMENT DRAWING	
1	CATCHMENT DRAWING FOR EAST GATE	DRN/MH/AMBRT/01
C	HVAC DRAWING	
1	HVAC DRAWING FOR EAST GATE SECURITY AREA	HVAC/MH/AMBRT/01
D	3D-VIEWS	
1	EAST GATE-3D VIEW-01	3D/MH/AMBRT/01
2	EAST GATE-3D VIEW-02	3D/MH/AMBRT/02
3	EAST GATE-3D VIEW-03	3D/MH/AMBRT/03
4	EAST GATE-3D VIEW-04	3D/MH/AMBRT/04
5	EAST GATE-3D VIEW-05	3D/MH/AMBRT/05
6	EAST GATE-3D VIEW-06	3D/MH/AMBRT/06
7	EAST GATE-3D VIEW-07	3D/MH/AMBRT/07
	SECURITY OFFICE	
A	ARCHITECTURAL DRAWING	
1	SECURITY OFFICE -GROUND FLOOR PLAN	ARC/MH/AMBRT/01
2	SECURITY OFFICE - FRONT ELEVATION	ARC/MH/AMBRT/02
B	FLOORING DRAWING	
1	FLOORING DRAWING OF SECURITY OFFICE- GROUND FLOOR PLAN	FL/MH/AMBRT/01
C	FALSE CEILING DRAWING	
1	FALSE CEILING DRAWING OF SECURITY OFFICE- GROUND FLOOR PLAN	FC/MH/AMBRT/01
D	HVAC DRAWING	
1	HVAC DRAWING OF SECURITY OFFICE- GROUND FLOOR PLAN	HVAC/MH/AMBRT/01
E	PH DRAWING	
1	PH DRAWING OF SECURITY OFFICE- GROUND FLOOR PLAN	PH/MH/AMBRT/01
2	PH DRAWING OF SECURITY OFFICE- TERRACE PLAN	PH/MH/AMBRT/02
E	ELECTRICAL DRAWING	
1	ILLUMINATION DRAWING OF SECURITY OFFICE- GROUND FLOOR PLAN	EL/MH/AMBRT/01
F	FIRE FIGHTING DRAWING	
1	FIRE FIGHTING DRAWING OF SECURITY OFFICE- GROUND FLOOR PLAN	FF/MH/AMBRT/01
	BASTION	
A	ARCHITECTURAL DRAWING	
1	BASTION -GROUND & FIRST FLOOR PLAN	ARC/MH/AMBRT/01
	MARKETING OFFICE	
A	ARCHITECTURAL DRAWING	
1	MARKETING OFFICE -GROUND FLOOR PLAN	ARC/MH/AMBRT/01



KEY PLAN:

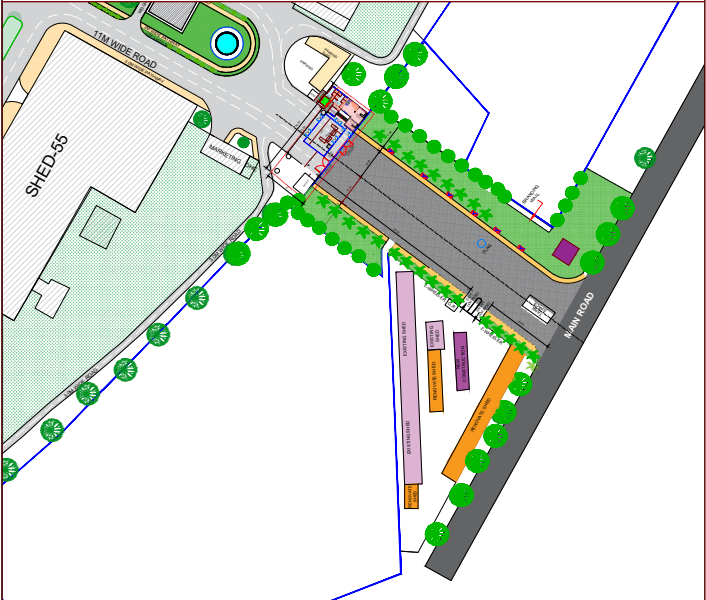

LEGEND	DESCRIPTION
	PROPOSED STORM WATER DRAINAGE
	LANDSCAPING
	CC ROAD WITH MASTIC BITUMEN COATING
	MS SHED
	INTERLOCKING PAVER BLOCK (80MM THICK)
	EXISTING DRAIN
	STORM WATER CATCHMENT AREA
	CHAMBER FOR DRAIN
	SAUCER DRAIN
	BASTION
	NP2 PIPE FROM CHAMBER TO DRAIN
	GRANITE FLOORING
	PERFORATED DRAIN


SUBMITTED BY
ROPEWAYS DIVISION, 2ND FLOOR, PLOT NO.- 62, INSTITUTIONAL AREA, SECTOR-18, GURGAON - 122015 (HARYANA)
PHONE: 0124-2977225
EMAIL: ROPEWAYS@WAPCOS.CO.IN

CLIENT
 ARMOURED VEHICLES NIGAM LIMITED
A GOVERNMENT OF INDIA ENTERPRISE,
MINISTRY OF DEFENCE


PROJECT
RENOVATION OF EAST GATE &
DEVELOPMENT OF SECURITY ROOM AT
MTPF AVNL AMBERNATH, MAHARASHTRA

DRAWING
EAST GATE -MASTER PLAN


SCALE	NTS	DATE	28-02-2025	
DRAWN	CHECKED			APPROVED
MOHIT RATHORE	RAJAT SINGH			
DRG. NO :	ARC/MH/AMBRT/01			REVISIONS
				0

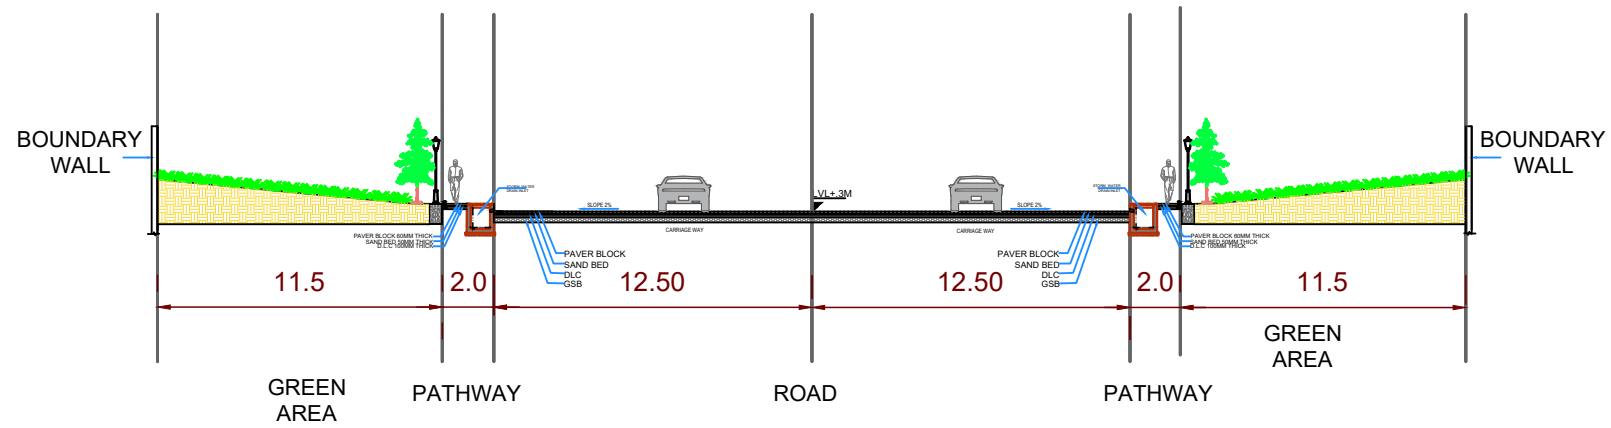

SECTION-AA'

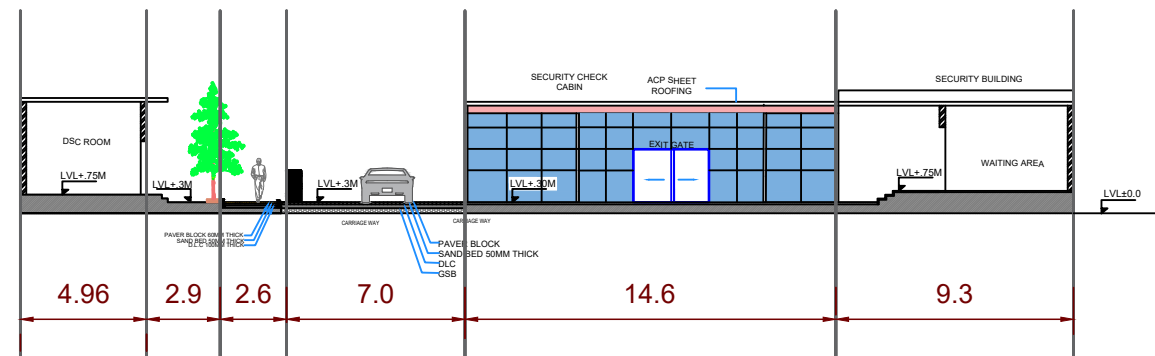


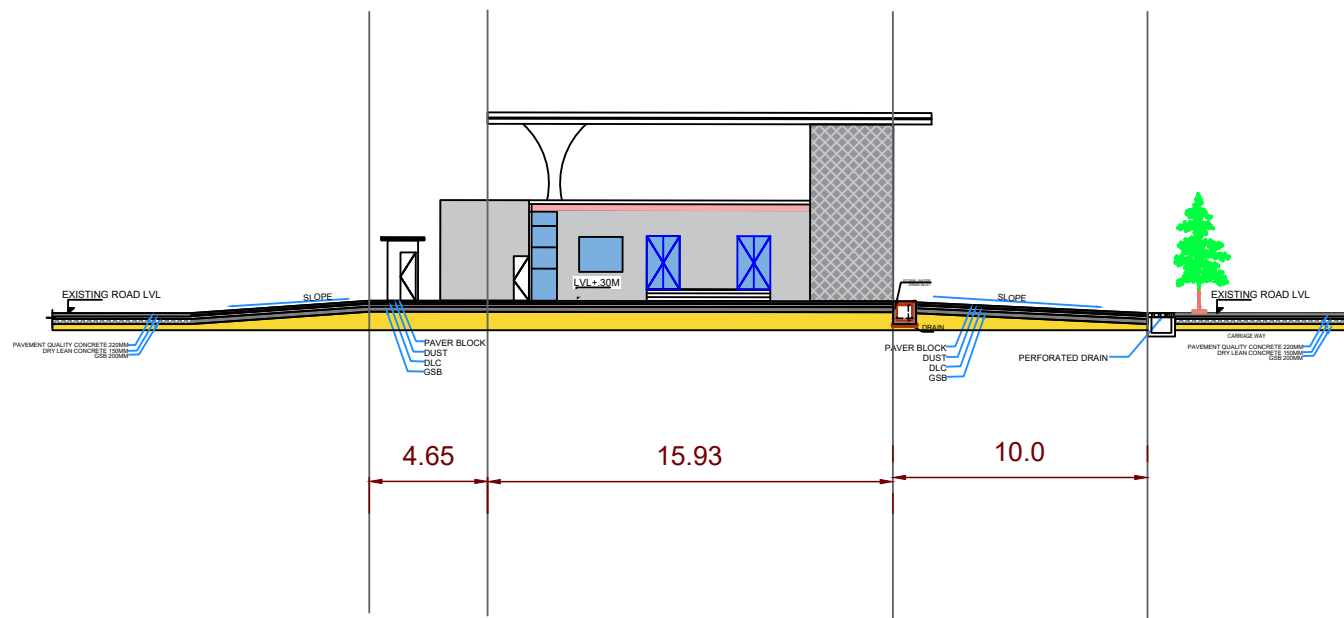

SECTION-XX'





SECTION-YY'

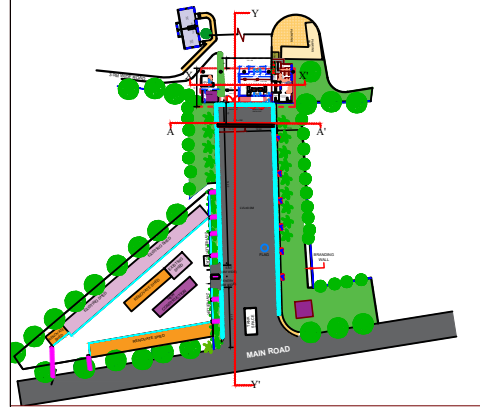KEY PLAN:



SUBMITTED BY		ROPEWAYS DIVISION, 2ND FLOOR, PLOT NO.- 62, INSTITUTIONAL AREA, SECTOR-18, GURGAON - 122015 (HARYANA) PHONE: 0124-2977225 EMAIL: ROPEWAYS@WAPCOS.CO.IN	
			
CLIENT	ARMOURED VEHICLES NIGAM LIMITED A GOVERNMENT OF INDIA ENTERPRISE, MINISTRY OF DEFENCE		
			
PROJECT	RENOVATION OF EAST GATE & DEVELOPMENT OF SECURITY ROOM AT MTPF AVNL AMBERNATH, MAHARASHTRA		
DRAWING	EAST GATE-ROAD SECTIONS		
SCALE	NTS	DATE	28-02-2025
DRAWN	CHECKED		APPROVED
MOHIT RATHORE		RAJAT SINGH	
DRG. NO :		ARC/MH/AMBR/01A	
		REVISIONS	
		0	

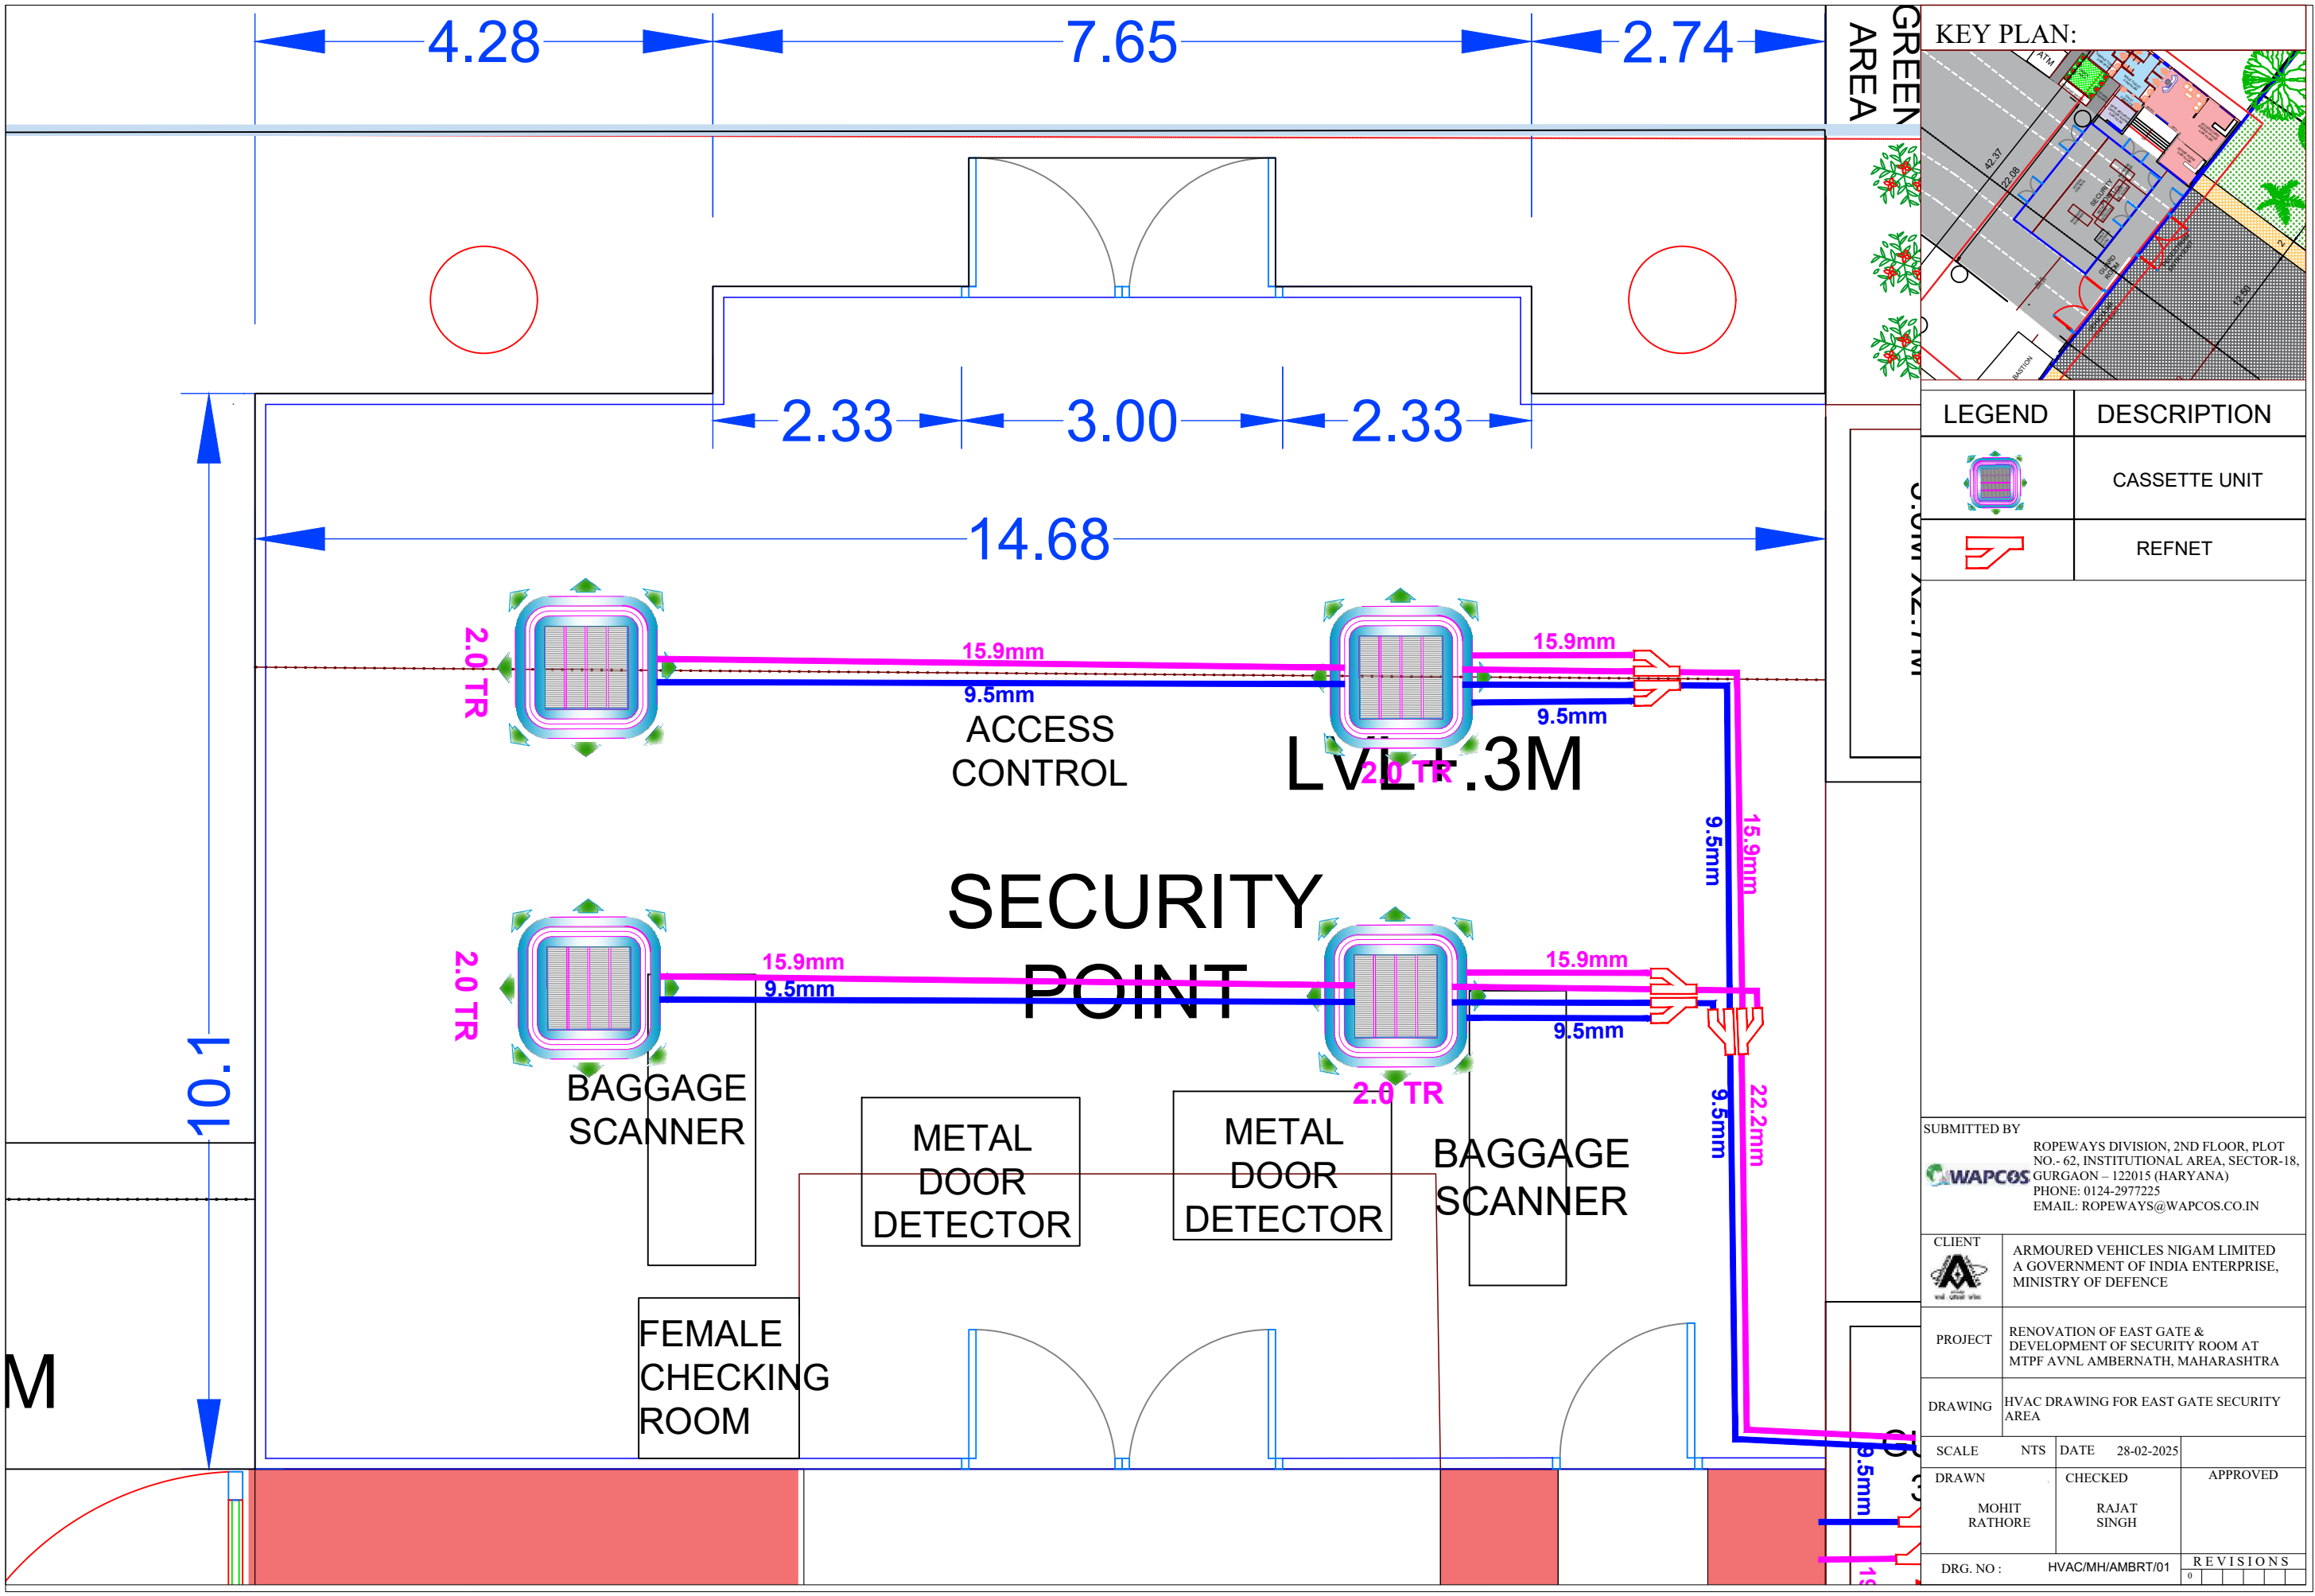


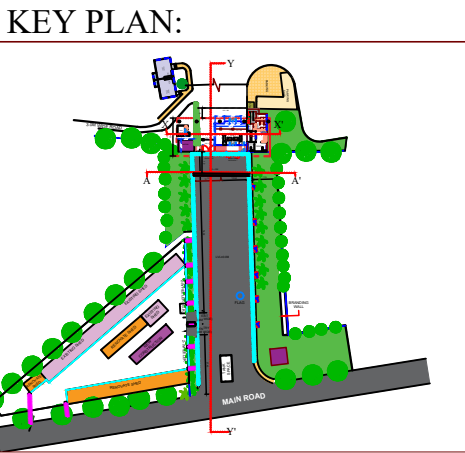

SUBMITTED BY			
ROPEWAYS DIVISION, 2ND FLOOR, PLOT NO.- 62, INSTITUTIONAL AREA, SECTOR-18, GURGAON - 122015 (HARYANA)			
PHONE: 0124-2977225			
EMAIL: ROPEWAYS@WAPCOS.CO.IN			
CLIENT	ARMOURED VEHICLES NIGAM LIMITED A GOVERNMENT OF INDIA ENTERPRISE, MINISTRY OF DEFENCE		
PROJECT	RENOVATION OF EAST GATE & DEVELOPMENT OF SECURITY ROOM AT MTPF AVNL AMBERNATH, MAHARASHTRA		
DRAWING	EAST GATE-3D VIEW-01		
SCALE	NTS	DATE	28-02-2025
DRAWN	CHECKED	APPROVED	
MOHIT RATHORE	RAJAT SINGH		
DRG. NO : 3D/MH/AMBRT/01		REVISIONS	
		0	



KEY PLAN:

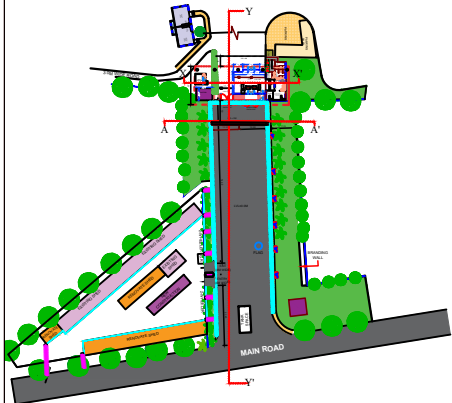

SUBMITTED BY
ROPEWAYS DIVISION, 2ND FLOOR, PLOT NO.- 62, INSTITUTIONAL AREA, SECTOR-18, GURGAON - 122015 (HARYANA)
PHONE: 0124-2977225
EMAIL: ROPEWAYS@WAPCOS.CO.IN


CLIENT
ARMOURED VEHICLES NIGAM LIMITED
A GOVERNMENT OF INDIA ENTERPRISE,
MINISTRY OF DEFENCE



PROJECT
RENOVATION OF EAST GATE &
DEVELOPMENT OF SECURITY ROOM AT
MTPF AVNL AMBERNATH, MAHARASHTRA

DRAWING
EAST GATE-3D VIEW-02

SCALE	NTS	DATE	28-02-2025	APPROVED
DRAWN		CHECKED		
	MOHIT RATHORE		RAJAT SINGH	

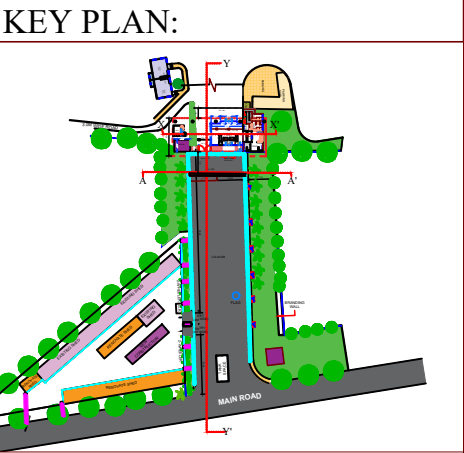
DRG. NO :	3D/MH/AMBR/02	REVISIONS
		0



SUBMITTED BY		ROPEWAYS DIVISION, 2ND FLOOR, PLOT NO.- 62, INSTITUTIONAL AREA, SECTOR-18, GURGAON – 122015 (HARYANA) PHONE: 0124-2977225 EMAIL: ROPEWAYS@WAPCOS.CO.IN			
					
CLIENT	ARMoured VEHICLES NIGAM LIMITED A GOVERNMENT OF INDIA ENTERPRISE, MINISTRY OF DEFENCE				
					
PROJECT	RENOVATION OF EAST GATE & DEVELOPMENT OF SECURITY ROOM AT MTPF AVNL AMBERNATH, MAHARASHTRA				
DRAWING	EAST GATE-3D VIEW-03				
SCALE	NTS	DATE	28-02-2025		
DRAWN		CHECKED		APPROVED	
MOHIT RATHORE		RAJAT SINGH			
DRG. NO : 3D/MH/AMBR/03				REVISIONS	
				0	




KEY PLAN:

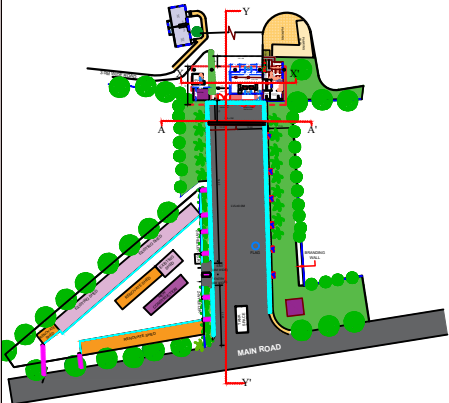

SUBMITTED BY
ROPEWAYS DIVISION, 2ND FLOOR, PLOT NO.- 62, INSTITUTIONAL AREA, SECTOR-18, GURGAON - 122015 (HARYANA)
PHONE: 0124-2977225
EMAIL: ROPEWAYS@WAPCOS.CO.IN


CLIENT	ARMoured VEHICLES NIGAM LIMITED A GOVERNMENT OF INDIA ENTERPRISE, MINISTRY OF DEFENCE		
PROJECT	RENOVATION OF EAST GATE & DEVELOPMENT OF SECURITY ROOM AT MTPF AVNL AMBERNATH, MAHARASHTRA		
DRAWING	EAST GATE-3D VIEW-04		
SCALE	NTS	DATE	28-02-2025
DRAWN	CHECKED	APPROVED	
MOHIT RATHORE	RAJAT SINGH		
DRG. NO :	3D/MH/AMBR/04	REVISIONS	
		0	

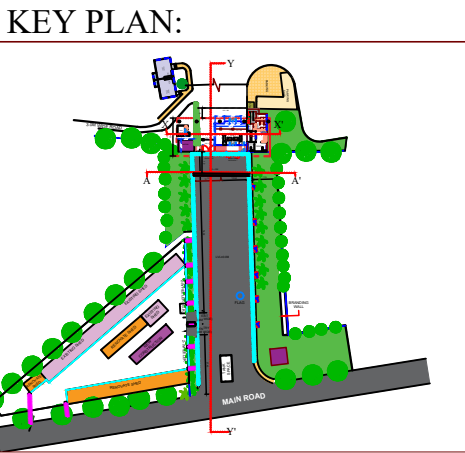

SUBMITTED BY			
ROPEWAYS DIVISION, 2ND FLOOR, PLOT NO.- 62, INSTITUTIONAL AREA, SECTOR-18, GURGAON - 122015 (HARYANA)			
PHONE: 0124-2977225			
EMAIL: ROPEWAYS@WAPCOS.CO.IN			
CLIENT	ARMoured VEHICLES NIGAM LIMITED A GOVERNMENT OF INDIA ENTERPRISE, MINISTRY OF DEFENCE		
PROJECT	RENOVATION OF EAST GATE & DEVELOPMENT OF SECURITY ROOM AT MTPF AVNL AMBERNATH, MAHARASHTRA		
DRAWING	EAST GATE-3D VIEW-05		
SCALE	NTS	DATE	28-02-2025
DRAWN	CHECKED	APPROVED	
MOHIT RATHORE	RAJAT SINGH		
DRG. NO : 3D/MH/AMBR/05		REVISIONS	
		0	



KEY PLAN:

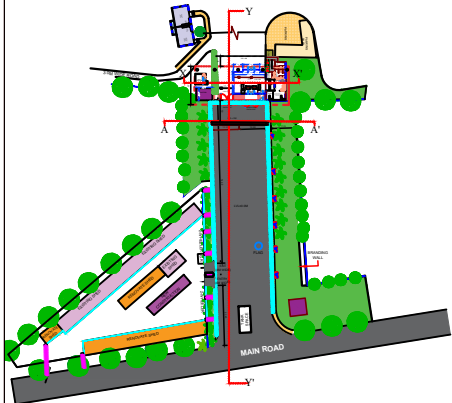

SUBMITTED BY
ROPEWAYS DIVISION, 2ND FLOOR, PLOT
NO.- 62, INSTITUTIONAL AREA, SECTOR-18,
GURGAON - 122015 (HARYANA)
PHONE: 0124-2977225
EMAIL: ROPEWAYS@WAPCOS.CO.IN

CLIENT
ARMoured VEHICLES NIGAM LIMITED
A GOVERNMENT OF INDIA ENTERPRISE,
MINISTRY OF DEFENCE

PROJECT
RENOVATION OF EAST GATE &
DEVELOPMENT OF SECURITY ROOM AT
MTPF AVNL AMBERNATH, MAHARASHTRA


DRAWING
EAST GATE-3D VIEW-06

SCALE	NTS	DATE	28-02-2025	APPROVED
DRAWN		CHECKED		
	MOHIT RATHORE		RAJAT SINGH	

DRG. NO :	3D/MH/AMBRT/06	REVISIONS
		0



KEY PLAN:

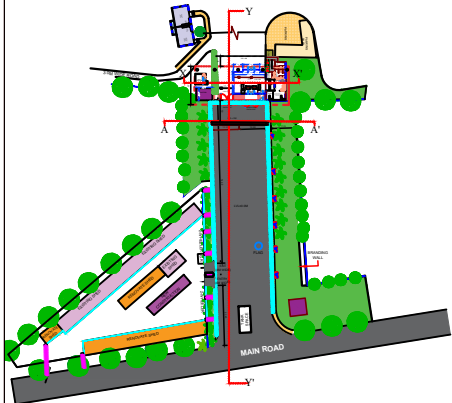

SUBMITTED BY
ROPEWAYS DIVISION, 2ND FLOOR, PLOT NO.- 62, INSTITUTIONAL AREA, SECTOR-18, GURGAON - 122015 (HARYANA)
PHONE: 0124-2977225
EMAIL: ROPEWAYS@WAPCOS.CO.IN


CLIENT
ARMOURED VEHICLES NIGAM LIMITED
A GOVERNMENT OF INDIA ENTERPRISE,
MINISTRY OF DEFENCE

PROJECT
RENOVATION OF EAST GATE &
DEVELOPMENT OF SECURITY ROOM AT
MTPF AVNL AMBERNATH, MAHARASHTRA


DRAWING
EAST GATE-3D VIEW-07

SCALE	NTS	DATE	28-02-2025	APPROVED
DRAWN		CHECKED		
	MOHIT RATHORE		RAJAT SINGH	

DRG. NO :	3D/MH/AMBRT/07	REVISIONS
		0

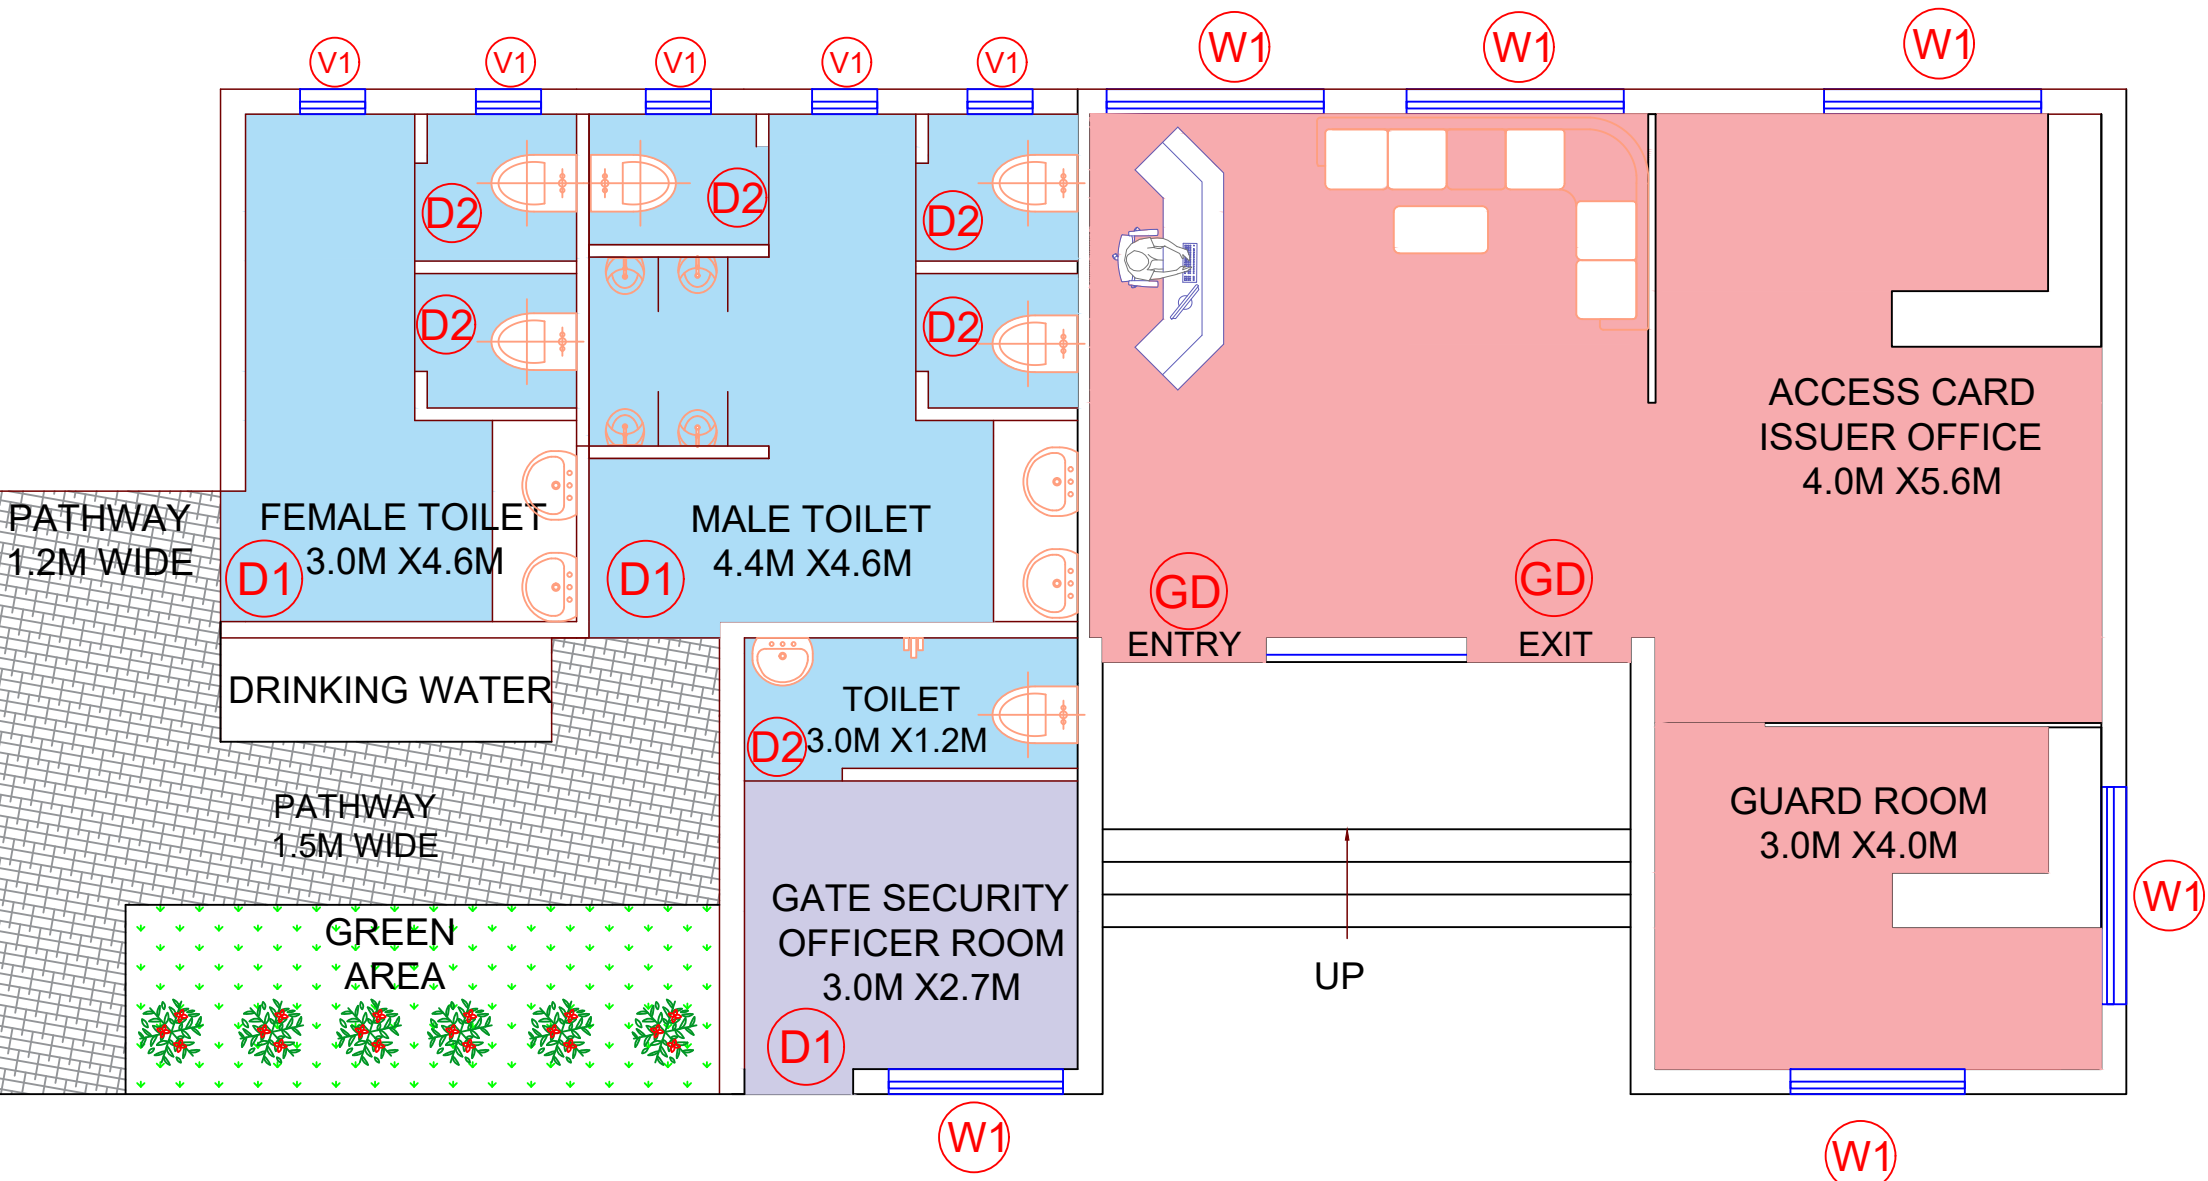

KEY PLAN:

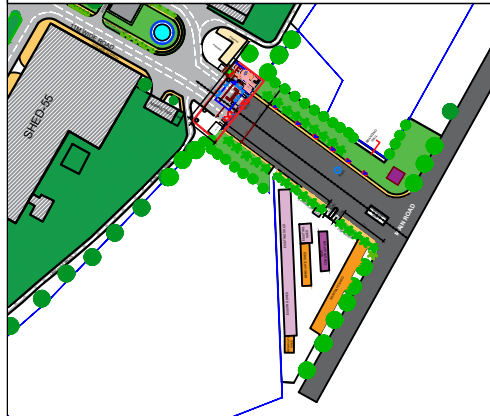

LEGENDS:

	GATE SECURITY/CHAMBERS
	RECEPTION AND WAITING AREA
	GUARD ROOM
	TOILETS

DOOR WINDOW SCHEDULE

S.NO.	TYPE	SILL	LINTEL	SIZE	QTY.
1.	GD	-	2500	2000X2500	1
2.	D1	-	2500	1200X2500	4
3.	D2	-	2100	900X2100	6
4.	W1	900	2500	2000X1600	7
5.	V1	1900	2500	600X600	4

SUBMITTED BY
ROPEWAYS DIVISION, 2ND FLOOR, PLOT NO.- 62, INSTITUTIONAL AREA, SECTOR-18, GURGAON - 122015 (HARYANA)
PHONE: 0124-2977225
EMAIL: ROPEWAYS@WAPCOS.CO.IN

CLIENT


ARMOURED VEHICLES NIGAM LIMITED
A GOVERNMENT OF INDIA ENTERPRISE,
MINISTRY OF DEFENCE

PROJECT
RENOVATION OF EAST GATE &
DEVELOPMENT OF SECURITY ROOM AT
MTPF AVNL AMBERNATH, MAHARASHTRA



DRAWING
SECURITY OFFICE -GROUND FLOOR PLAN

SCALE	NTS	DATE	28-02-2025
DRAWN	CHECKED	APPROVED	
MOHIT RATHORE	RAJAT SINGH		

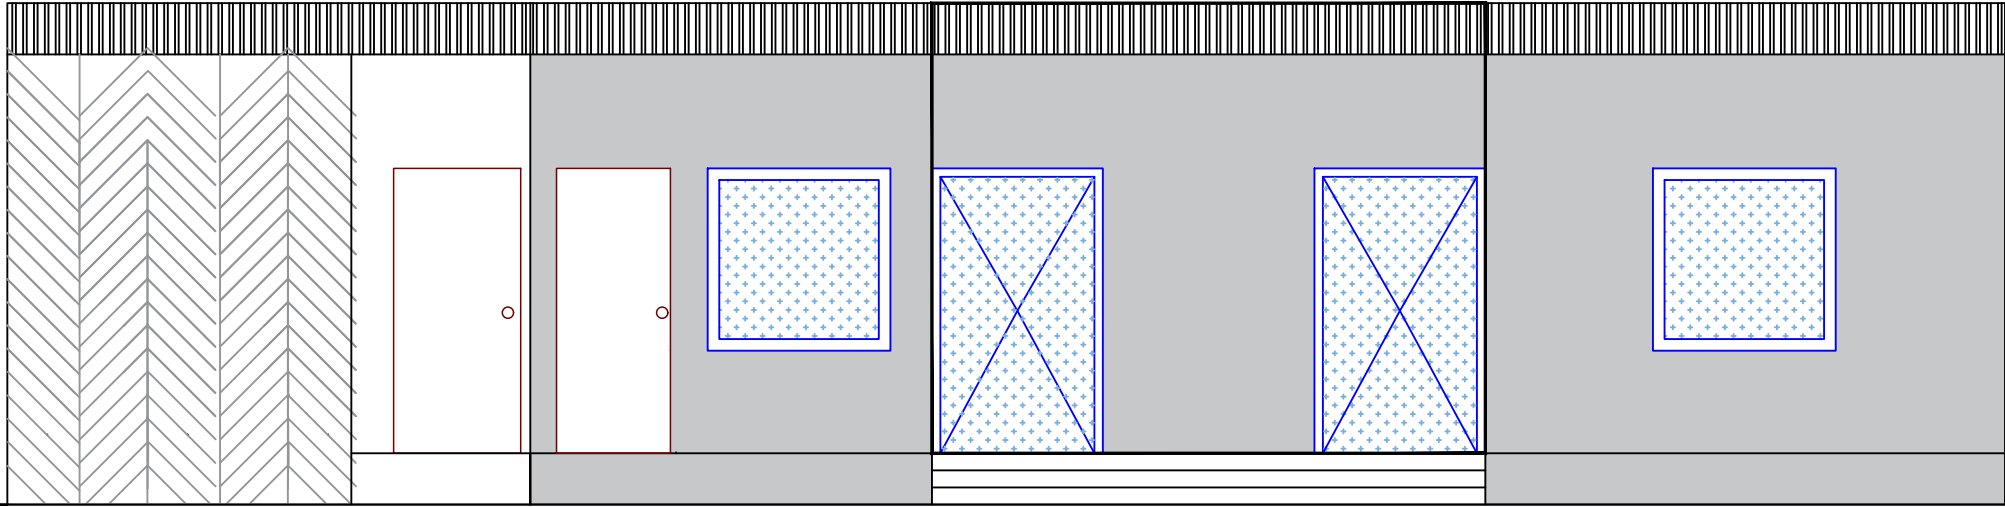DRG. NO :	ARC/MH/AMBR/01	REVISIONS
		0




FRONT ELEVATION

SUBMITTED BY		ROPEWAYS DIVISION, 2ND FLOOR, PLOT NO. - 62, INSTITUTIONAL AREA, SECTOR-18, GURGAON - 122015 (HARYANA) PHONE: 0124-2977225 EMAIL: ROPEWAYS@WAPCOS.CO.IN					
							
CLIENT		ARMOURD VEHICLES NIGAM LIMITED A GOVERNMENT OF INDIA ENTERPRISE, MINISTRY OF DEFENCE					
							
PROJECT		RENOVATION OF EAST GATE & DEVELOPMENT OF SECURITY ROOM AT MTPF AVNL AMBERNATH, MAHARASHTRA					
DRAWING		SECURITY OFFICE - FRONT ELEVATION					
SCALE		NTS	DATE	28-02-2025			
DRAWN		CHECKED		APPROVED			
MOHIT RATHORE		RAJAT SINGH					
DRG. NO :		ARC/MH/AMBR/02		REVISIONS			
				0			

ITEM	SIZE IN MM	MATERIAL	SYMBOL
VITRIFIED TILE ANTI-SKID (FLOOR)	600X600	MATT	<div></div>
VITRIFIED TILE (WALL)	600X600	MATT / GLOSS	


ITEM	SIZE IN MM	MATERIAL	SYMBOL
VITRIFIED TILE	600X1200	AS PER APPROVED DESIGN	<div></div>

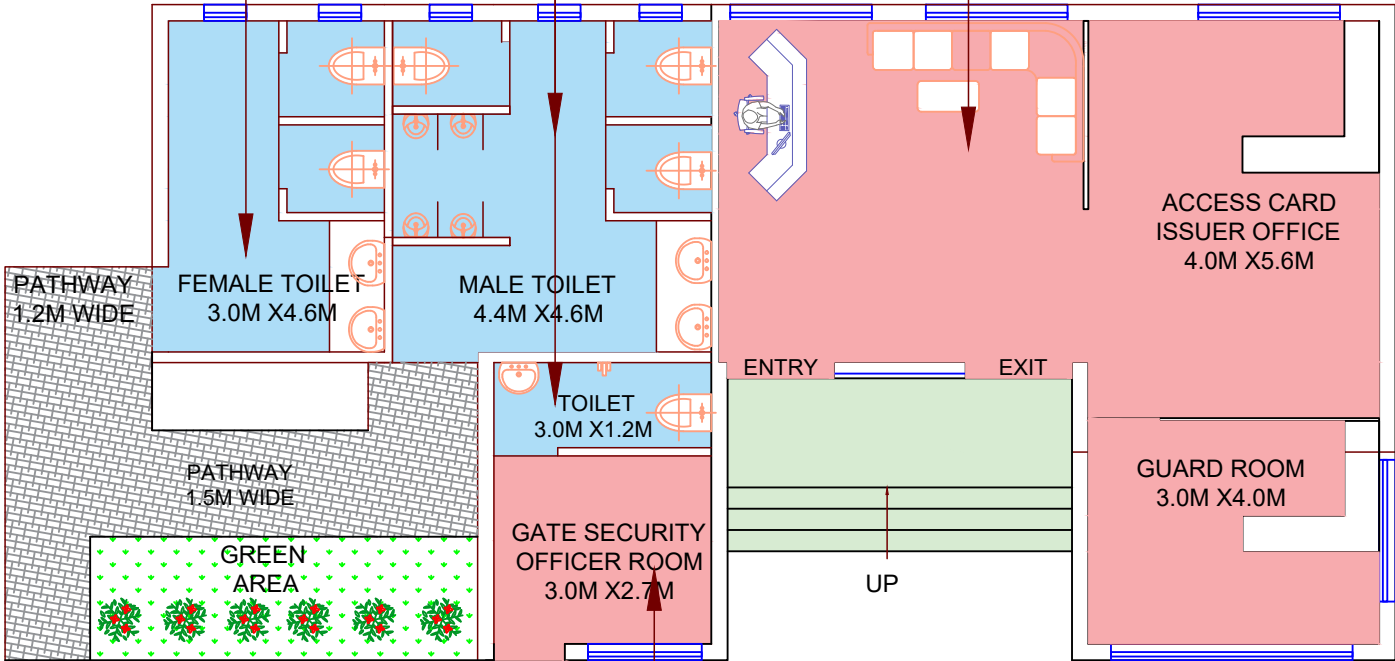


ITEM	SIZE IN MM	MATERIAL	SYMBOL
GRANITE	N/A	AS PER APPROVED DESIGN	<div></div>

ITEM	SIZE IN MM	MATERIAL	SYMBOL
VITRIFIED TILE	600X1200	AS PER APPROVED DESIGN	<div></div>

SUBMITTED BY			
ROPEWAYS DIVISION, 2ND FLOOR, PLOT NO.- 62, INSTITUTIONAL AREA, SECTOR-18, GURGAON - 122015 (HARYANA) PHONE: 0124-2977225 EMAIL: ROPEWAYS@WAPCOS.CO.IN			
CLIENT	ARMOURED VEHICLES NIGAM LIMITED A GOVERNMENT OF INDIA ENTERPRISE, MINISTRY OF DEFENCE		
PROJECT	RENOVATION OF EAST GATE & DEVELOPMENT OF SECURITY ROOM AT MTPF AVNL AMBERNATH, MAHARASHTRA		
DRAWING	FLOORING DRAWING OF SECURITY OFFICE- GROUND FLOOR PLAN		
SCALE	NTS	DATE	28-02-2025
DRAWN	CHECKED		APPROVED
MOHIT RATHORE	RAJAT SINGH		
DRG. NO :	FL/MH/AMBRT/01	REVISIONS	
		0	

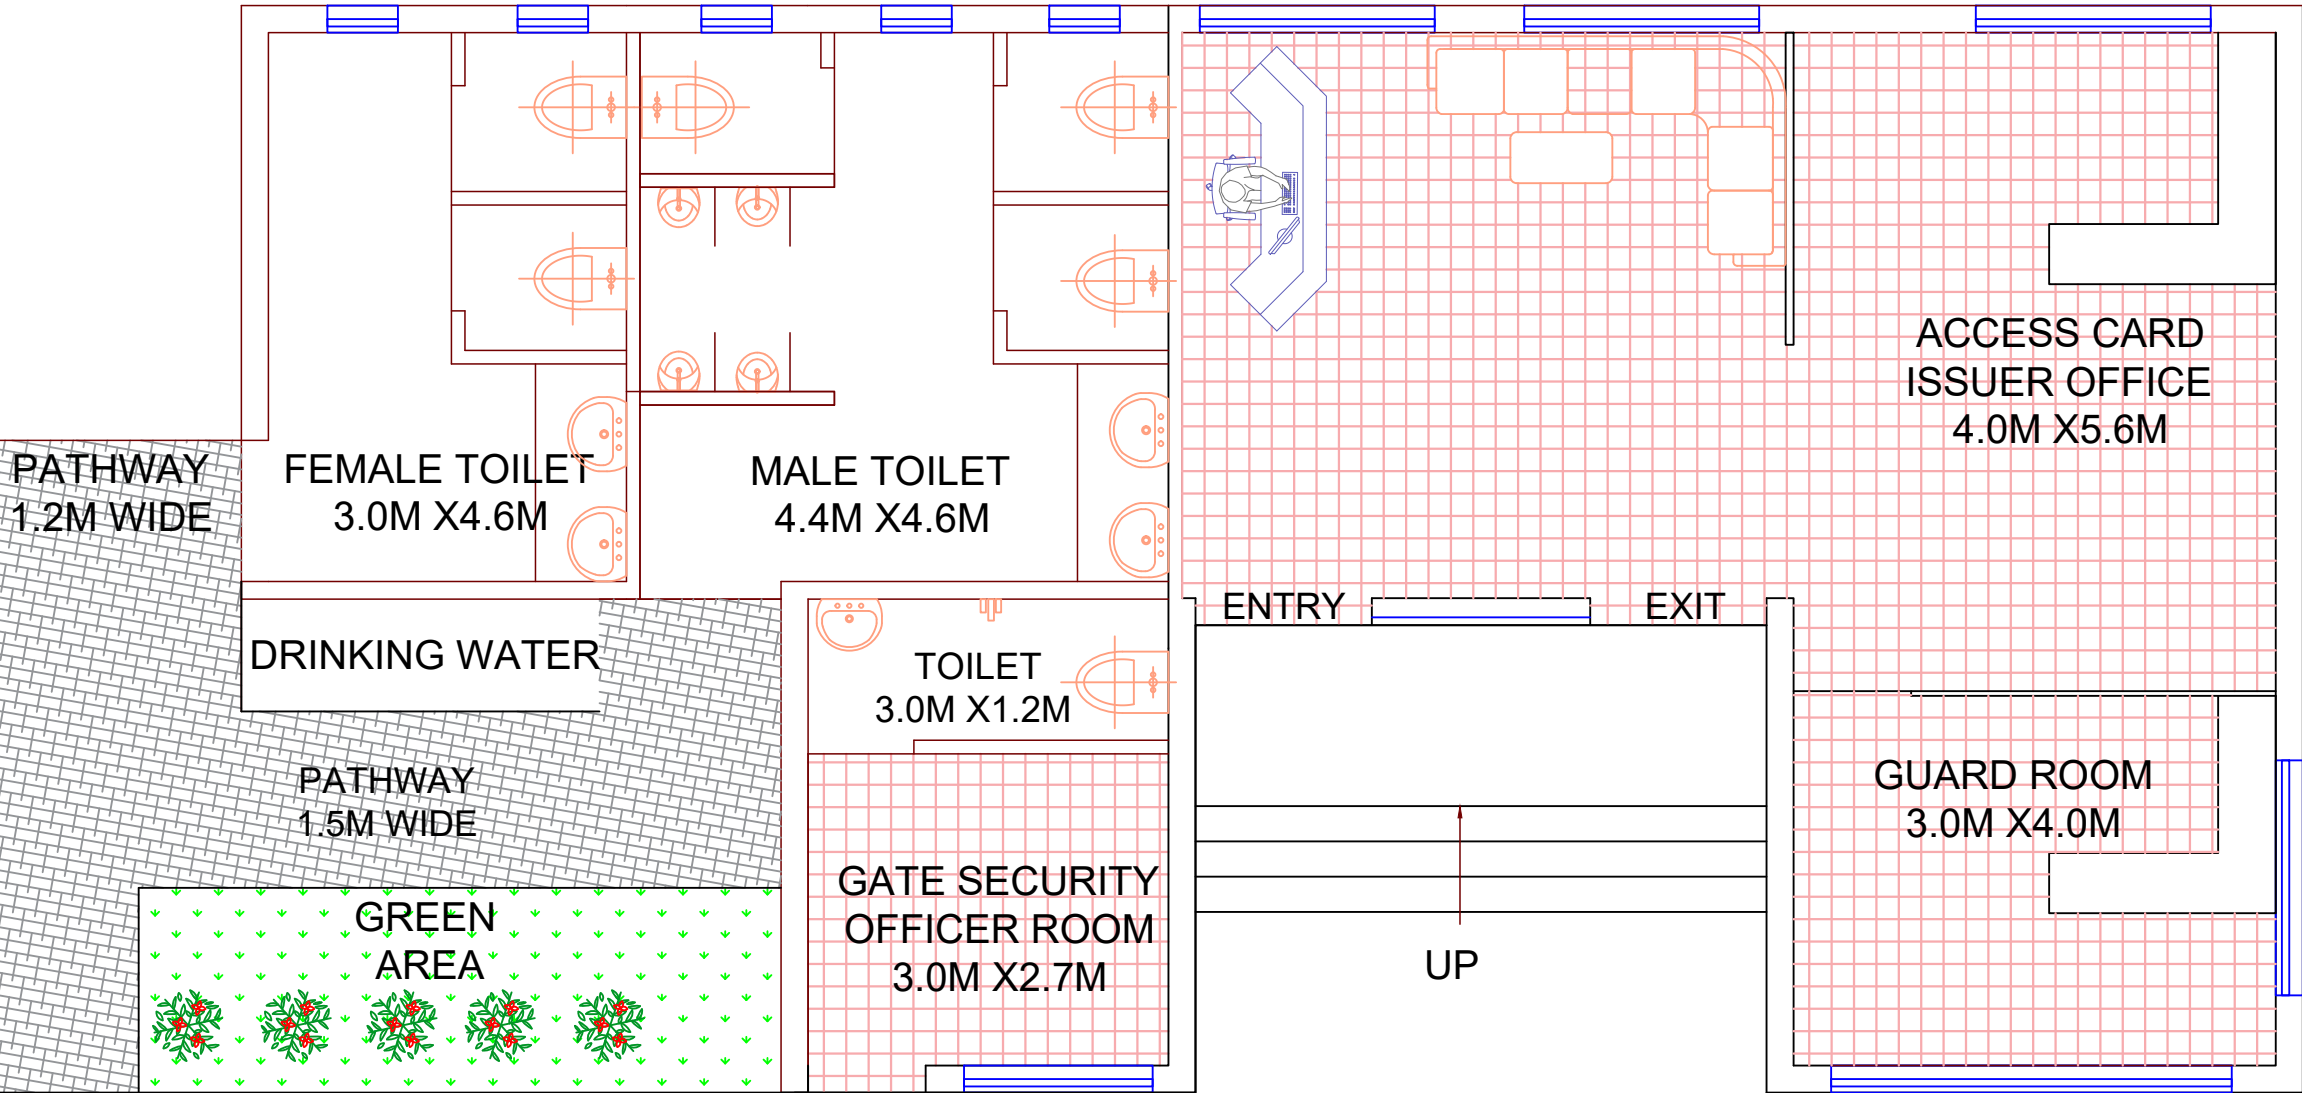

LEGENDS:				
		2'X2' GRG GRID CEILING		
SUBMITTED BY				
<div> ROPEWAYS DIVISION, 2ND FLOOR, PLOT NO.- 62, INSTITUTIONAL AREA, SECTOR-18, GURGAON – 122015 (HARYANA) PHONE: 0124-2977225 EMAIL: ROPEWAYS@WAPCOS.CO.IN</div>				
CLIENT		ARMOURED VEHICLES NIGAM LIMITED A GOVERNMENT OF INDIA ENTERPRISE, MINISTRY OF DEFENCE		
PROJECT		RENOVATION OF EAST GATE & DEVELOPMENT OF SECURITY ROOM AT MTPF AVNL AMBERNATH, MAHARASHTRA		
DRAWING		FALSE CEILING DRAWING OF SECURITY OFFICE- GROUND FLOOR PLAN		
SCALE	NTS	DATE	28-02-2025	
DRAWN		CHECKED	APPROVED	
MOHIT RATHORE		RAJAT SINGH		
DRG. NO :		FC/MH/AMBR/01	REVISIONS	
			0	

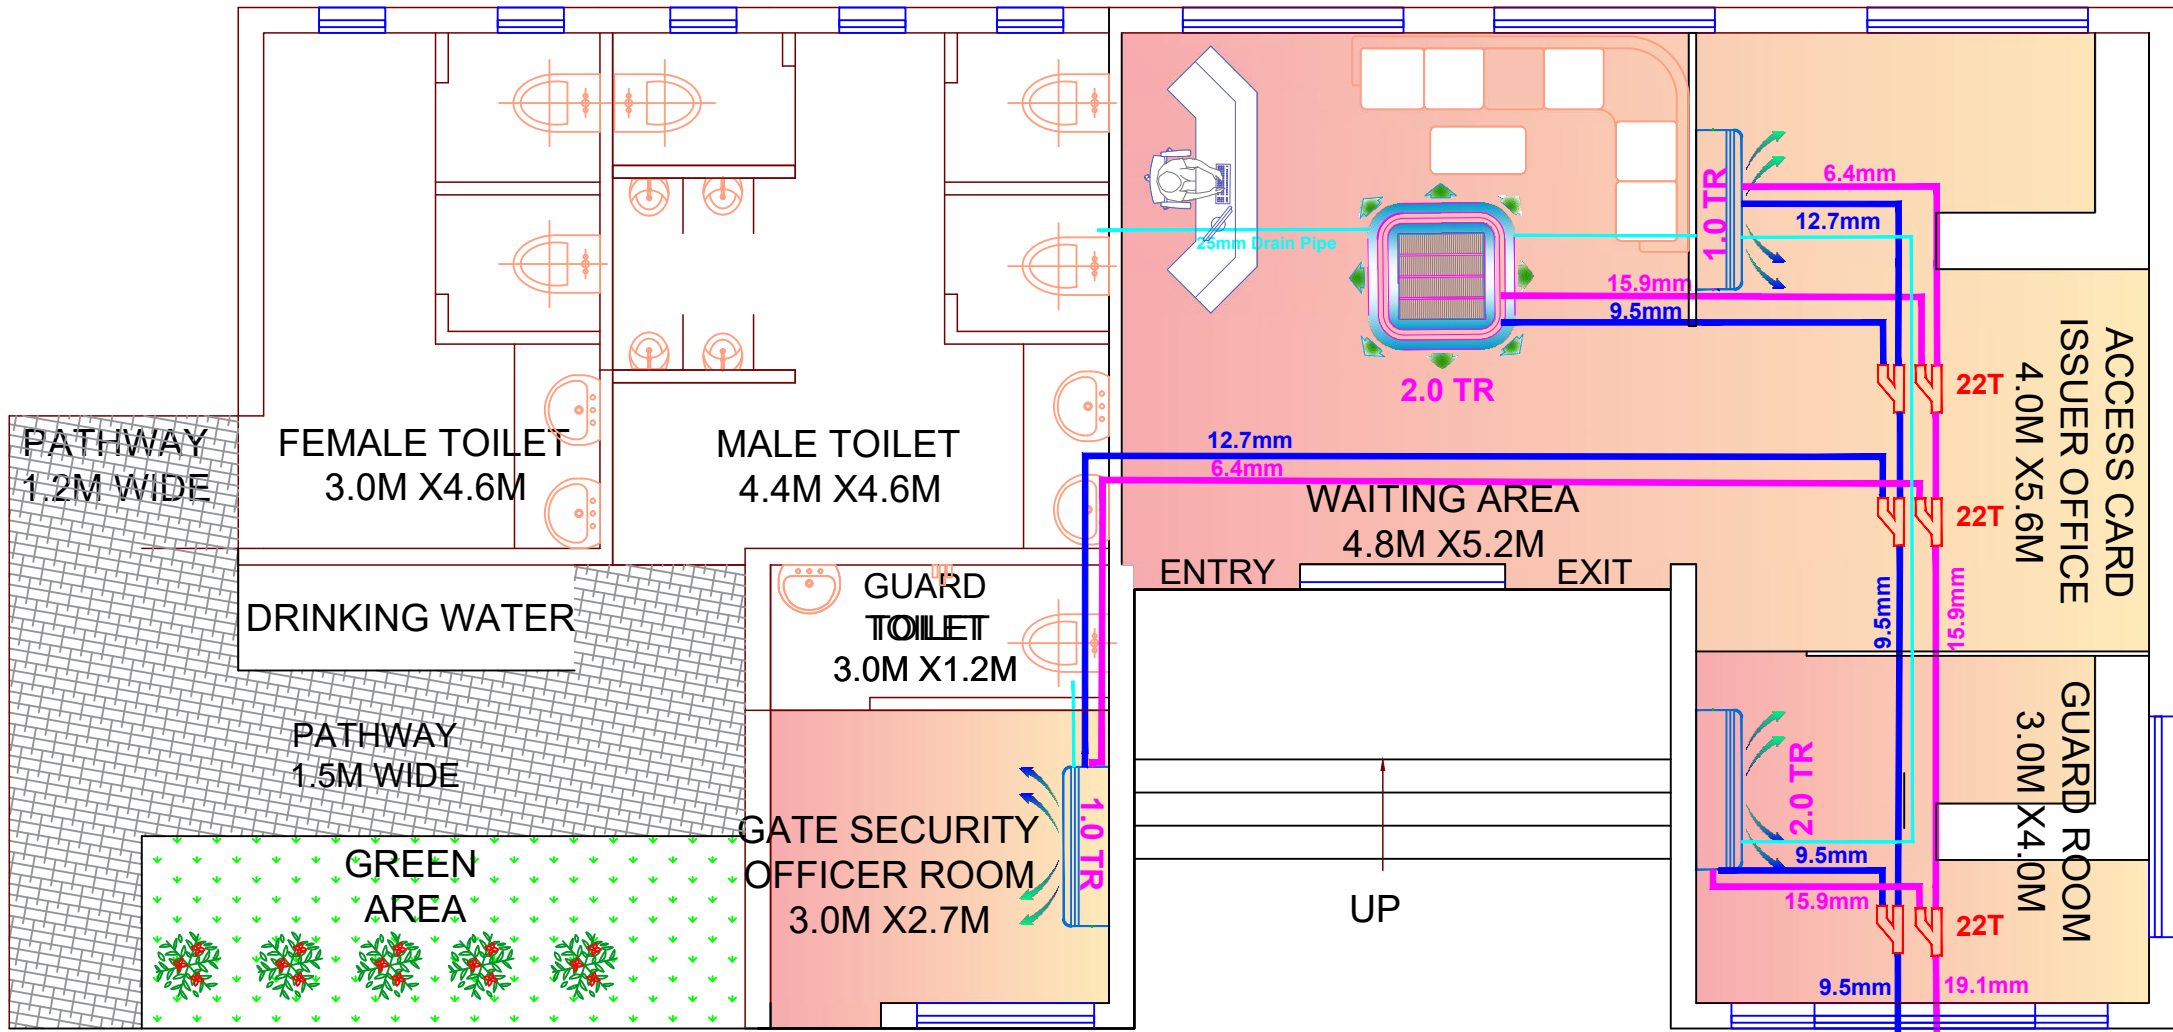

LEGEND	DESCRIPTION
	CASSETTE UNIT
	REFNET
	HVAC AREA
	SPLIT A.C.

SUBMITTED BY
ROPEWAYS DIVISION, 2ND FLOOR, PLOT NO.- 62, INSTITUTIONAL AREA, SECTOR-18, GURGAON - 122015 (HARYANA)
PHONE: 0124-2977225
EMAIL: ROPEWAYS@WAPCOS.CO.IN


CLIENT
ARMOURED VEHICLES NIGAM LIMITED
A GOVERNMENT OF INDIA ENTERPRISE,
MINISTRY OF DEFENCE

PROJECT
RENOVATION OF EAST GATE &
DEVELOPMENT OF SECURITY ROOM AT
MTPF AVNL AMBERNATH, MAHARASHTRA

DRAWING
HVAC DRAWING OF SECURITY OFFICE-
GROUND FLOOR PLAN

SCALE	NTS	DATE	28-02-2025
DRAWN	CHECKED	APPROVED	
MOHIT RATHORE	RAJAT SINGH		

DRG. NO :	HVAC/MH/AMBR/01	REVISIONS
		0

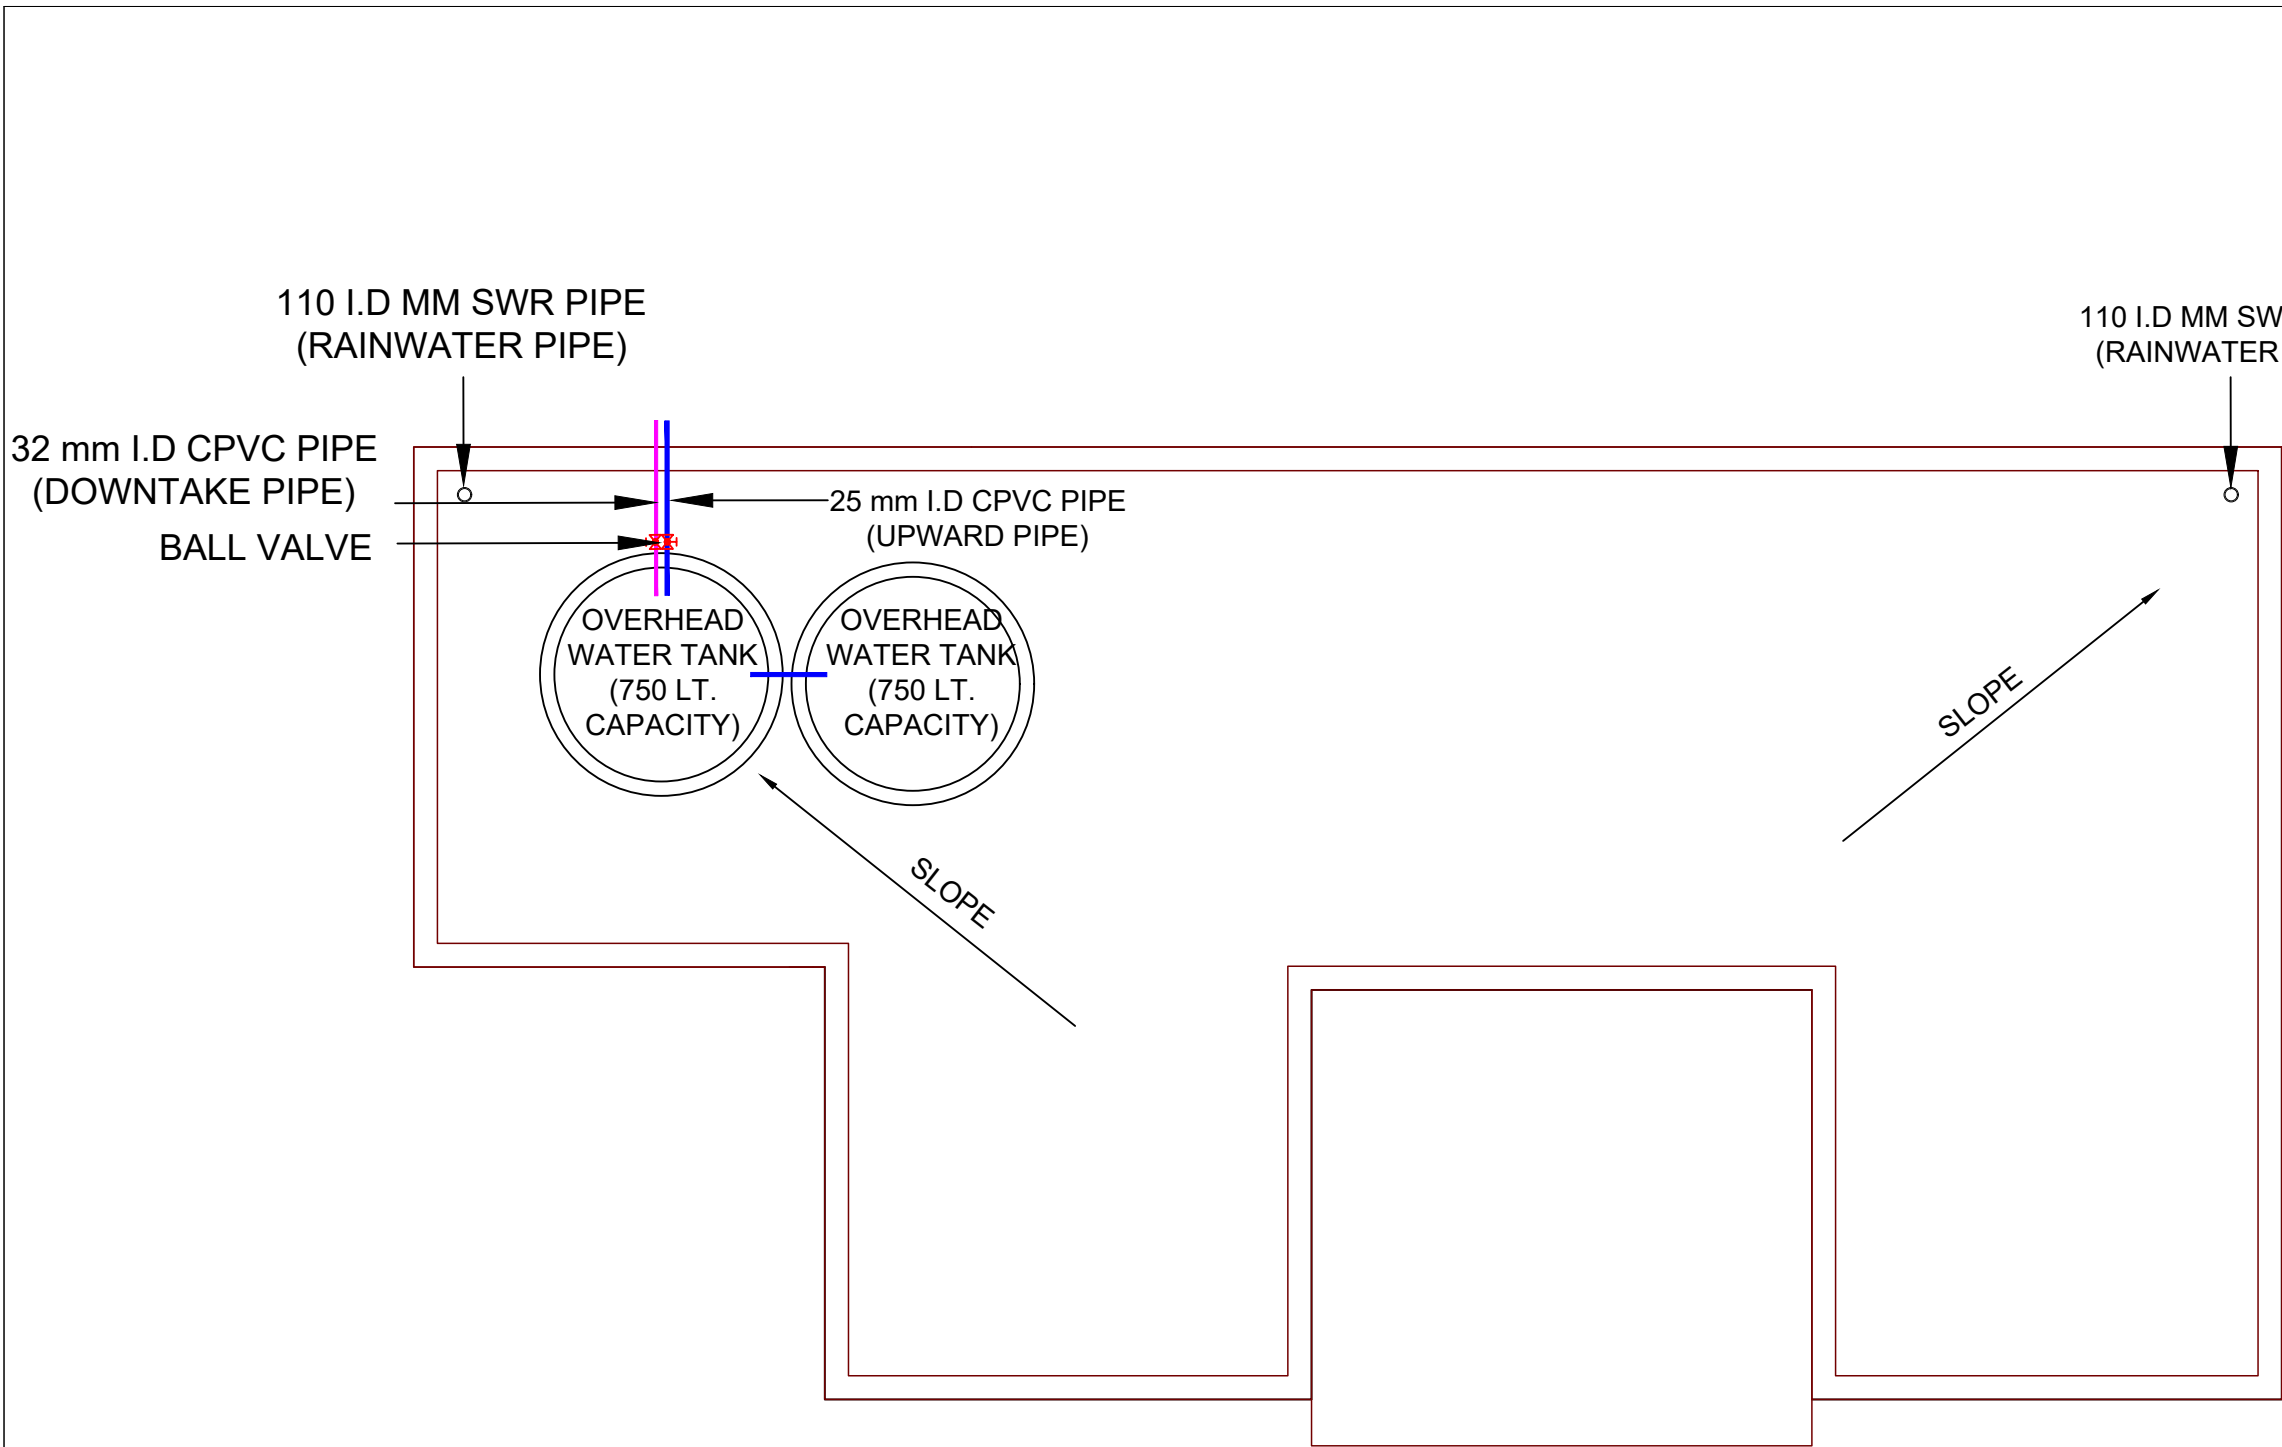

TERRACE PLAN

KEY PLAN:

LEGEND :-

S.NO.	DESCRIPTION	SYMBOLE
1.	25 mm CPVC PIPE	
2.	32 mm CPVC PIPE	
3.	BALL VALVE	

NOTE: ID- INTERNAL DIA.

SUBMITTED BY
ROPEWAYS DIVISION, 2ND FLOOR, PLOT NO.- 62, INSTITUTIONAL AREA, SECTOR-18, GURGAON - 122015 (HARYANA)
PHONE: 0124-2977225
EMAIL: ROPEWAYS@WAPCOS.CO.IN


CLIENT

ARMOURED VEHICLES NIGAM LIMITED
A GOVERNMENT OF INDIA ENTERPRISE,
MINISTRY OF DEFENCE







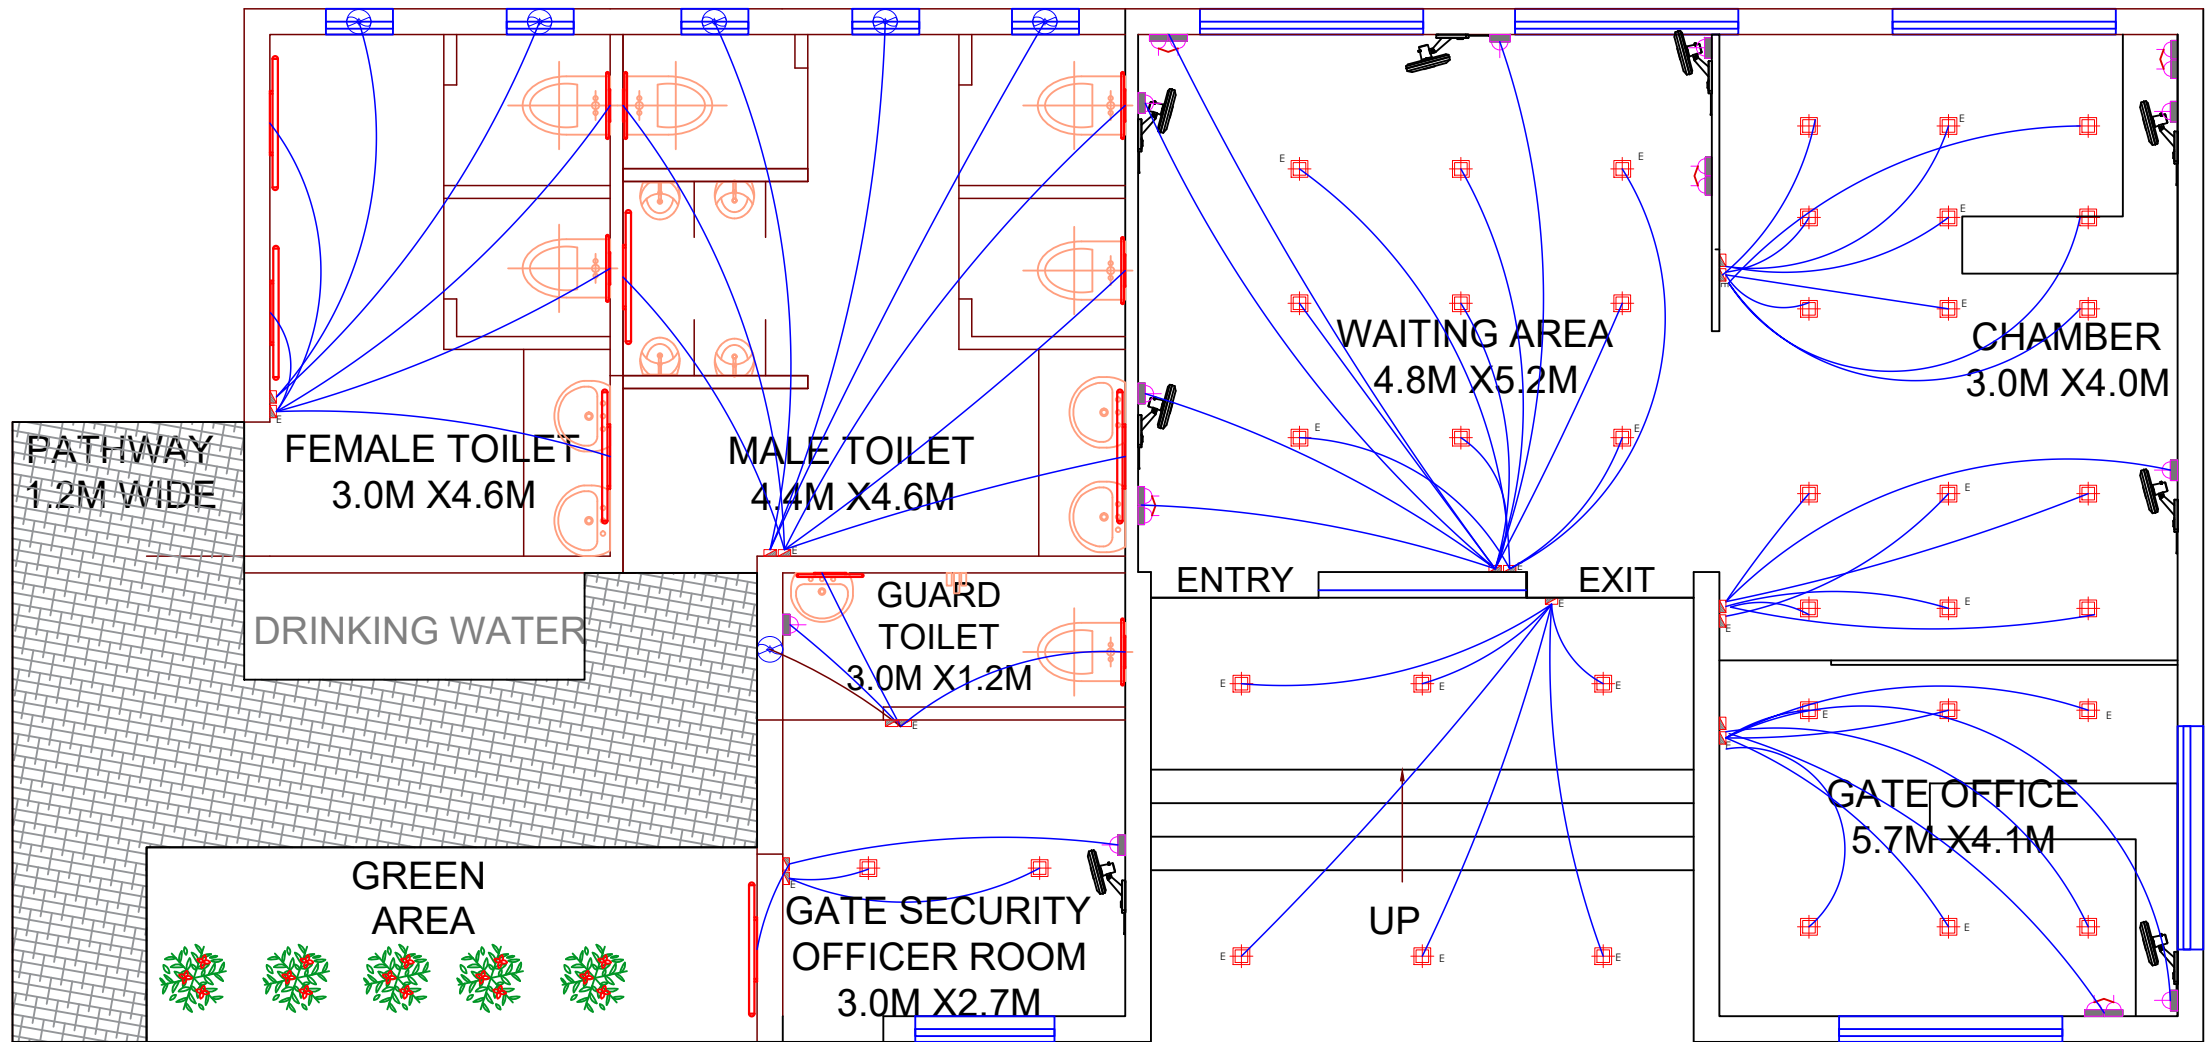


 
PROJECT
RENOVATION OF EAST GATE & DEVELOPMENT OF SECURITY ROOM AT MTPF AVNL AMBERNATH, MAHARASHTRA

DRAWING
PH DRAWING OF SECURITY OFFICE- TERRACE PLAN

SCALE	NTS	DATE	28-02-2025	
DRAWN	CHECKED	APPROVED		
MOHIT RATHORE	RAJAT SINGH			
DRG. NO :	PH/MH/AMBRT/02	REVISIONS		
		0		



LEGEND:

 E	Emergency Switch Board With 5A Socket
	Switch Board With 5A Socket
	15 Watt Recessed LED Light
	2X6 Amp Switch & Socket
	6Amp Switch & Socket
	16 Amp Switch & Socket
	Wall Fan
	10Watt LED Tube Light
	20Watt LED Tube Light
	300mm Exhaust Fan

SUBMITTED BY
ROPEWAYS DIVISION, 2ND FLOOR, PLOT NO.- 62, INSTITUTIONAL AREA, SECTOR-18, GURGAON - 122015 (HARYANA)
PHONE: 0124-2977225
EMAIL: ROPEWAYS@WAPCOS.CO.IN


CLIENT
ARMOURED VEHICLES NIGAM LIMITED
A GOVERNMENT OF INDIA ENTERPRISE,
MINISTRY OF DEFENCE

PROJECT
RENOVATION OF EAST GATE &
DEVELOPMENT OF SECURITY ROOM AT
MTPF AVNL AMBERNATH, MAHARASHTRA

DRAWING
ILLUMINATION DRAWING OF SECURITY
OFFICE- GROUND FLOOR PLAN

SCALE	NTS	DATE	28-02-2025
DRAWN	CHECKED	APPROVED	
MOHIT RATHORE	RAJAT SINGH		

DRG. NO :	EL/MH/AMBR/01	REVISIONS
		0

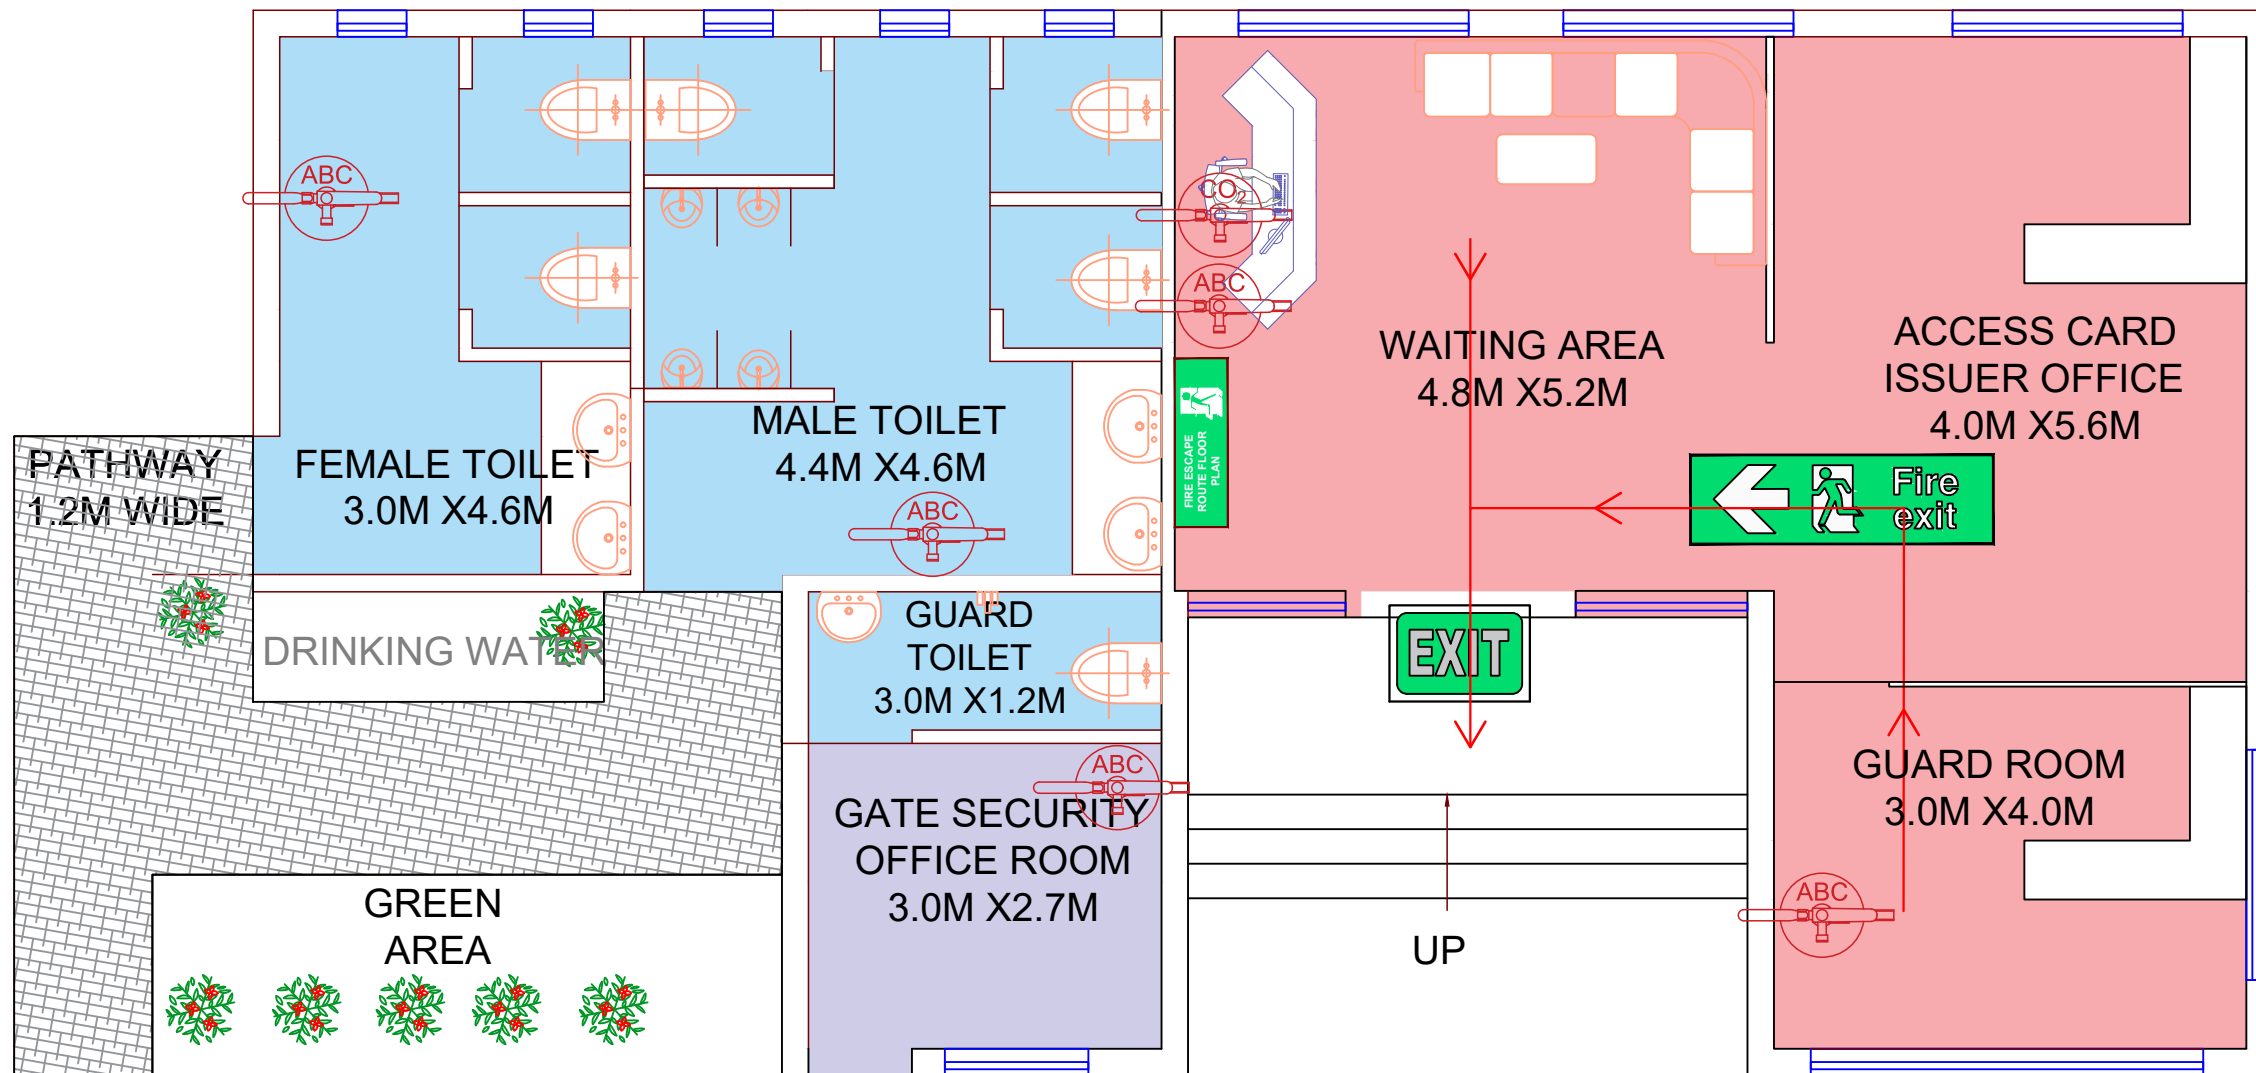

LEGEND		
S.NO.	DESCRIPTION	SYMBOL
1.	FIRE EXTINGUISHER POWDER TYPE	
2.	FIRE EXTINGUISHER CO2 TYPE	
3.	EXIT ROUTE SIGNAGE	
4.	FIRE EXIT SIGNAGE	
5.	FIRE ESCAPE ROUTE FLOOR PLAN	

SUBMITTED BY
ROPEWAYS DIVISION, 2ND FLOOR, PLOT NO.- 62, INSTITUTIONAL AREA, SECTOR-18, GURGAON - 122015 (HARYANA)
PHONE: 0124-2977225
EMAIL: ROPEWAYS@WAPCOS.CO.IN

CLIENT

ARMOURED VEHICLES NIGAM LIMITED
A GOVERNMENT OF INDIA ENTERPRISE,
MINISTRY OF DEFENCE


PROJECT
RENOVATION OF EAST GATE & DEVELOPMENT OF SECURITY ROOM AT MTPF AVNL AMBERNATH, MAHARASHTRA

DRAWING
FIRE FIGHTING DRAWING OF SECURITY OFFICE- GROUND FLOOR PLAN


SCALE NTS DATE 28-02-2025

DRAWN	CHECKED	APPROVED
MOHIT RATHORE	RAJAT SINGH	


DRG. NO :	FF/MH/AMBR/01	REVISIONS
		0

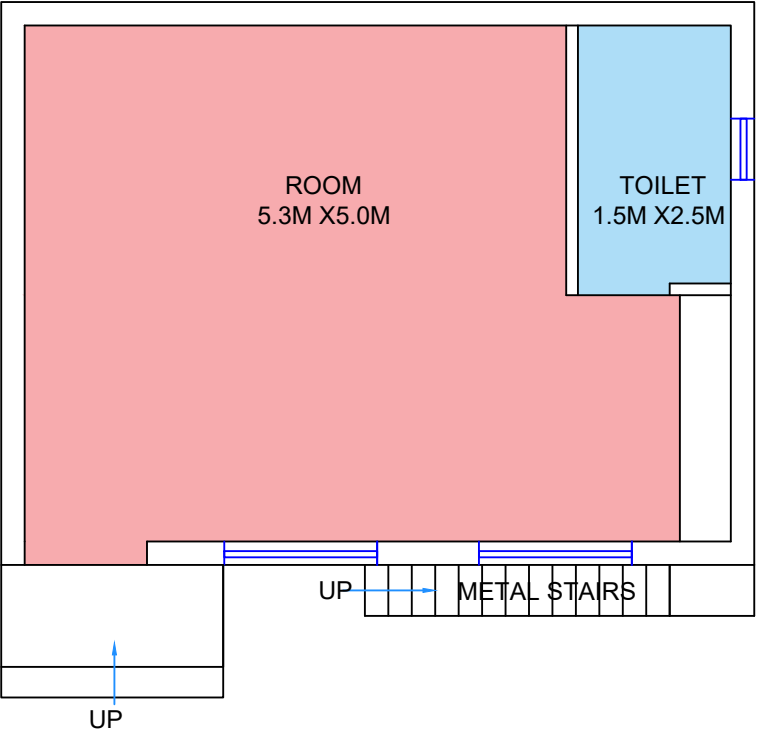


GROUND FLOOR

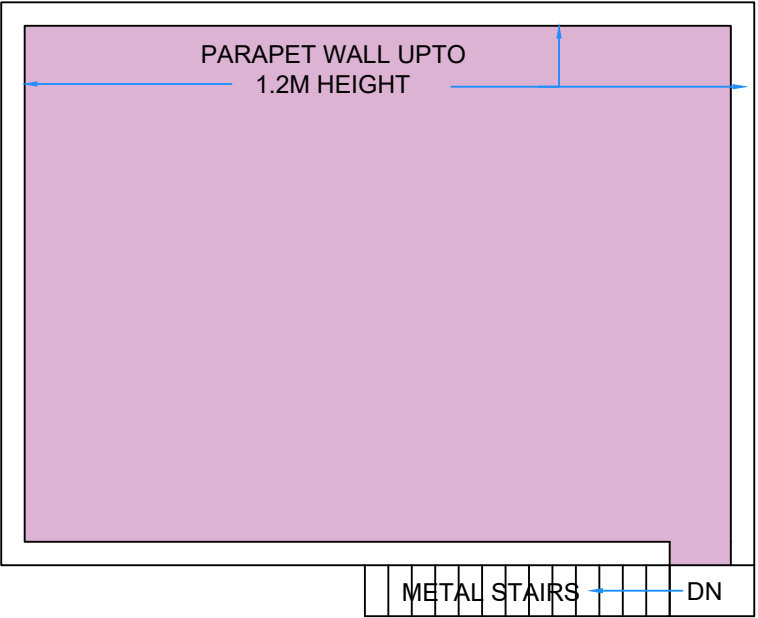


FIRST FLOOR

SUBMITTED BY		ROPEWAYS DIVISION, 2ND FLOOR, PLOT NO.- 62, INSTITUTIONAL AREA, SECTOR-18, GURGAON - 122015 (HARYANA) PHONE: 0124-2977225 EMAIL: ROPEWAYS@WAPCOS.CO.IN				
CLIENT		 ARMOURED VEHICLES NIGAM LIMITED A GOVERNMENT OF INDIA ENTERPRISE, MINISTRY OF DEFENCE				
PROJECT		RENOVATION OF EAST GATE & DEVELOPMENT OF SECURITY ROOM AT MTPF AVNL AMBERNATH, MAHARASHTRA				
DRAWING		BASTION -GROUND & FIRST FLOOR PLAN				
SCALE	NTS	DATE	28-02-2025			
DRAWN		CHECKED		APPROVED		
MOHIT RATHORE		RAJAT SINGH				
DRG. NO :		ARC/MH/AMBRT/01		REVISIONS		
				0		

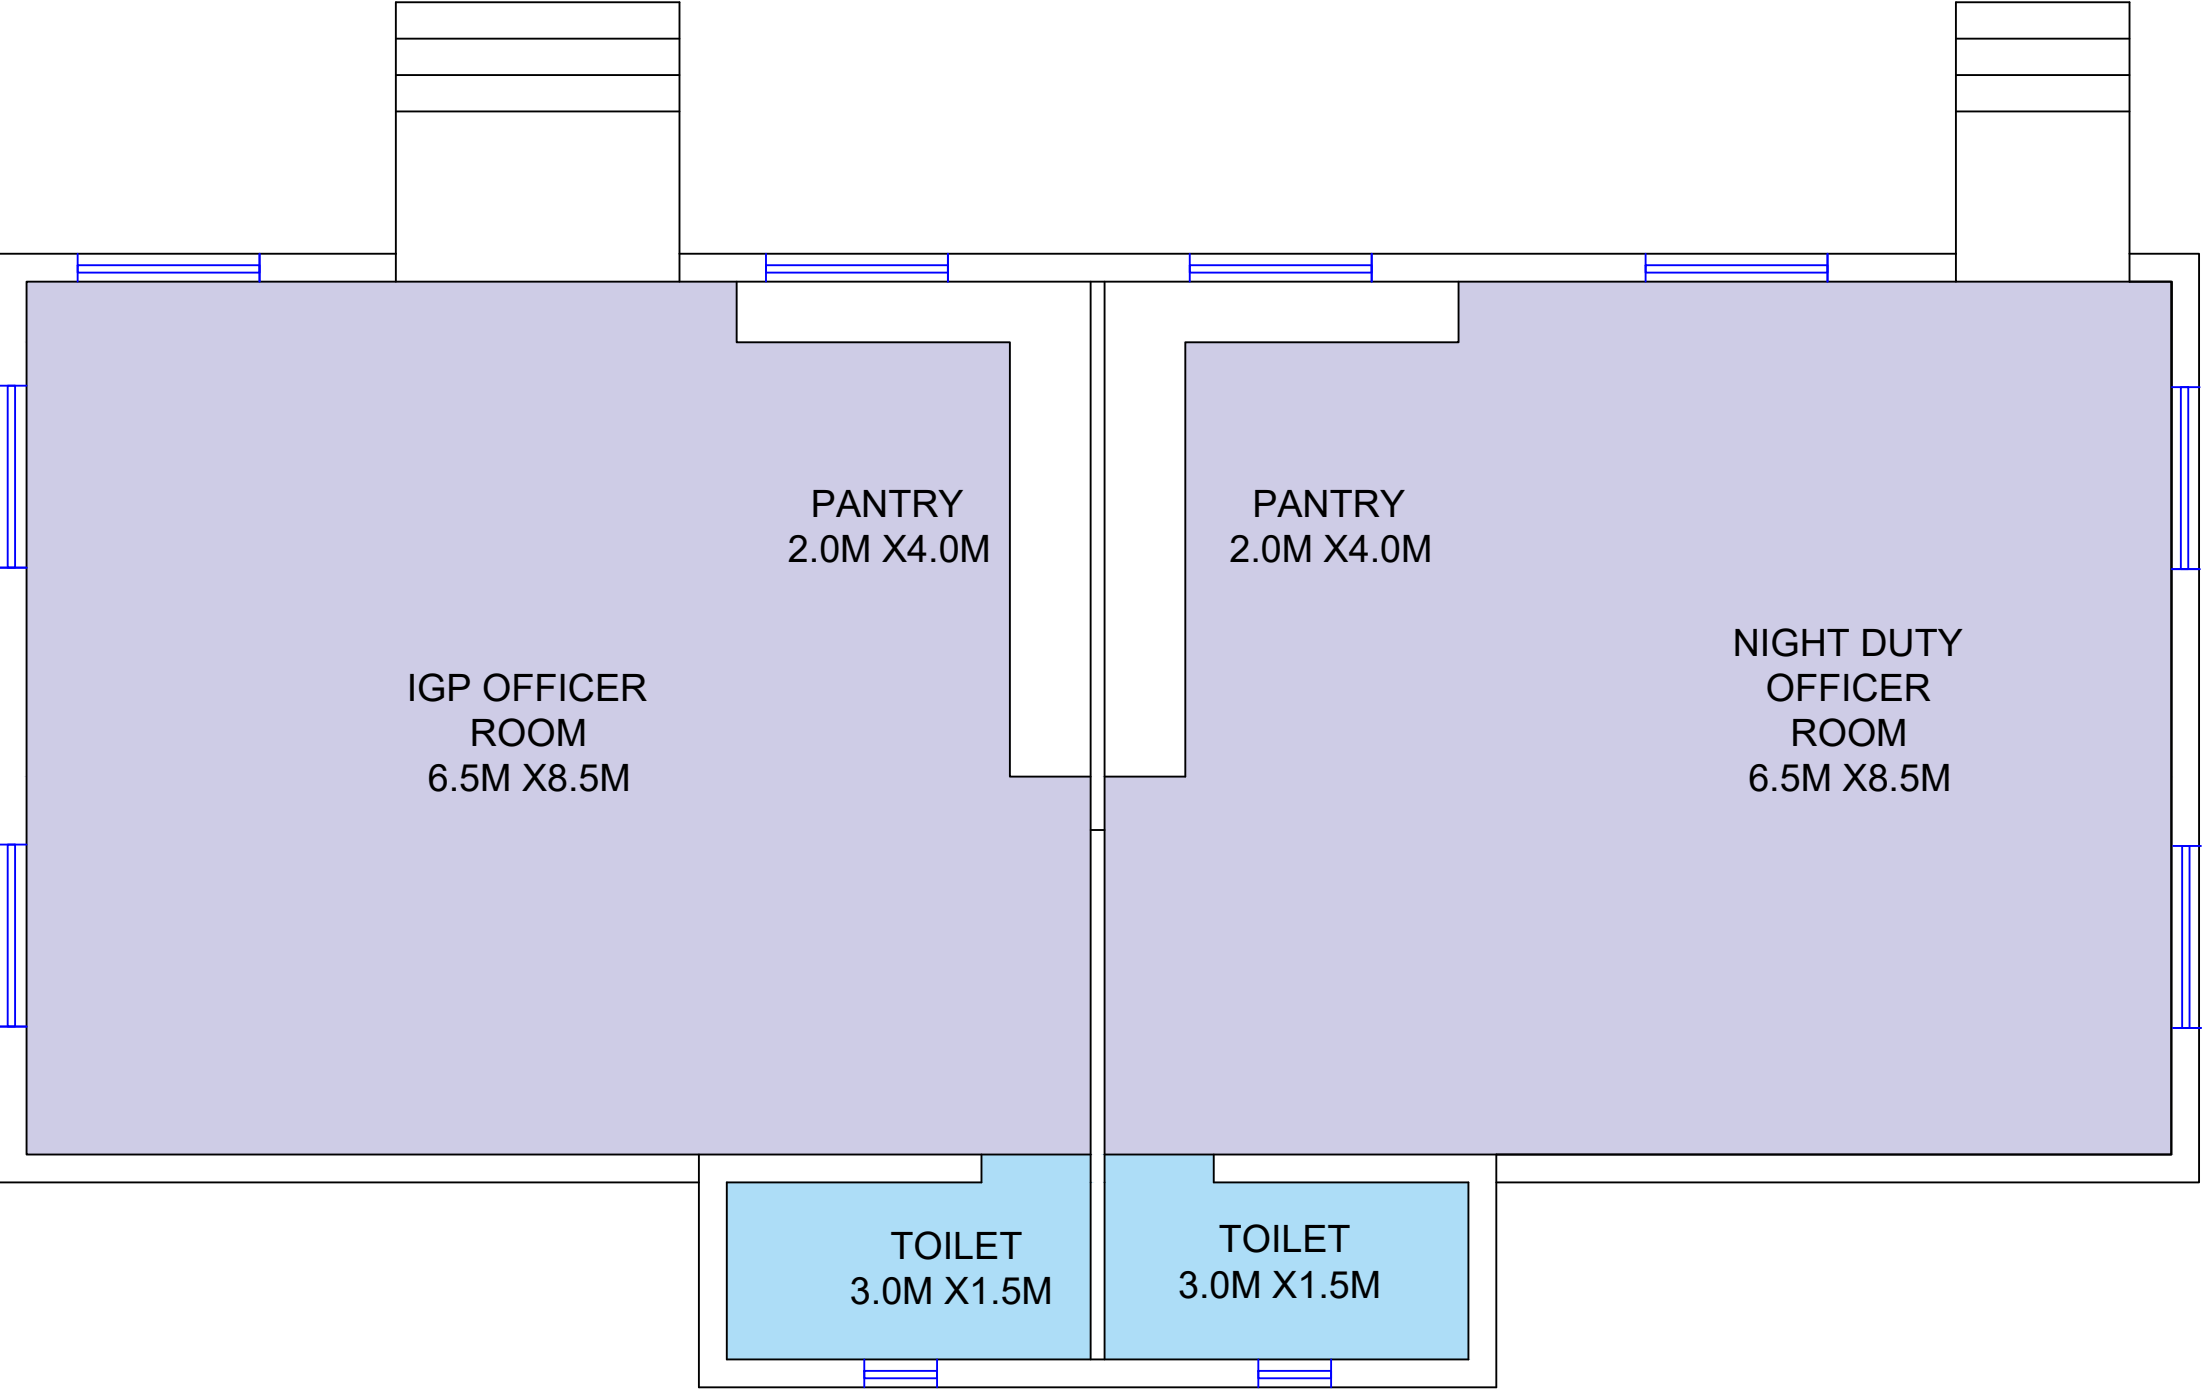

SUBMITTED BY
ROPEWAYS DIVISION, 2ND FLOOR, PLOT
NO.- 62, INSTITUTIONAL AREA, SECTOR-18,
GURGAON - 122015 (HARYANA)
PHONE: 0124-2977225
EMAIL: ROPEWAYS@WAPCOS.CO.IN

CLIENT
 ARMoured VEHICLES NIGAM LIMITED
A GOVERNMENT OF INDIA ENTERPRISE,
MINISTRY OF DEFENCE

PROJECT
RENOVATION OF EAST GATE &
DEVELOPMENT OF SECURITY ROOM AT
MTPF AVNL AMBERNATH, MAHARASHTRA

DRAWING
MARKETING OFFICE -GROUND FLOOR PLAN

SCALE
NTS
DATE
28-02-2025

DRAWN	CHECKED	APPROVED
MOHIT RATHORE	RAJAT SINGH	

DRG. NO :	ARC/MH/AMBR/01	REVISIONS
		0